


- Notes
1. Copyright Reserved
 2. Work to figured dimensions only. Do not scale drawing.
 3. The contractor is responsible for checking all levels and dimensions on site and shall refer all discrepancies to the Architect
 4. Where appropriate, for details of r.c. structure, or mechanical and electrical details, see Engineers drawings
 5. Proprietary items shall be fixed in strict accordance with manufacturers instructions.
 6. Sizes of proprietary items shall be checked with manufacturer.
 7. The contractor shall be responsible for the coordination of structure, finishes and services.

OSi PLACE Map

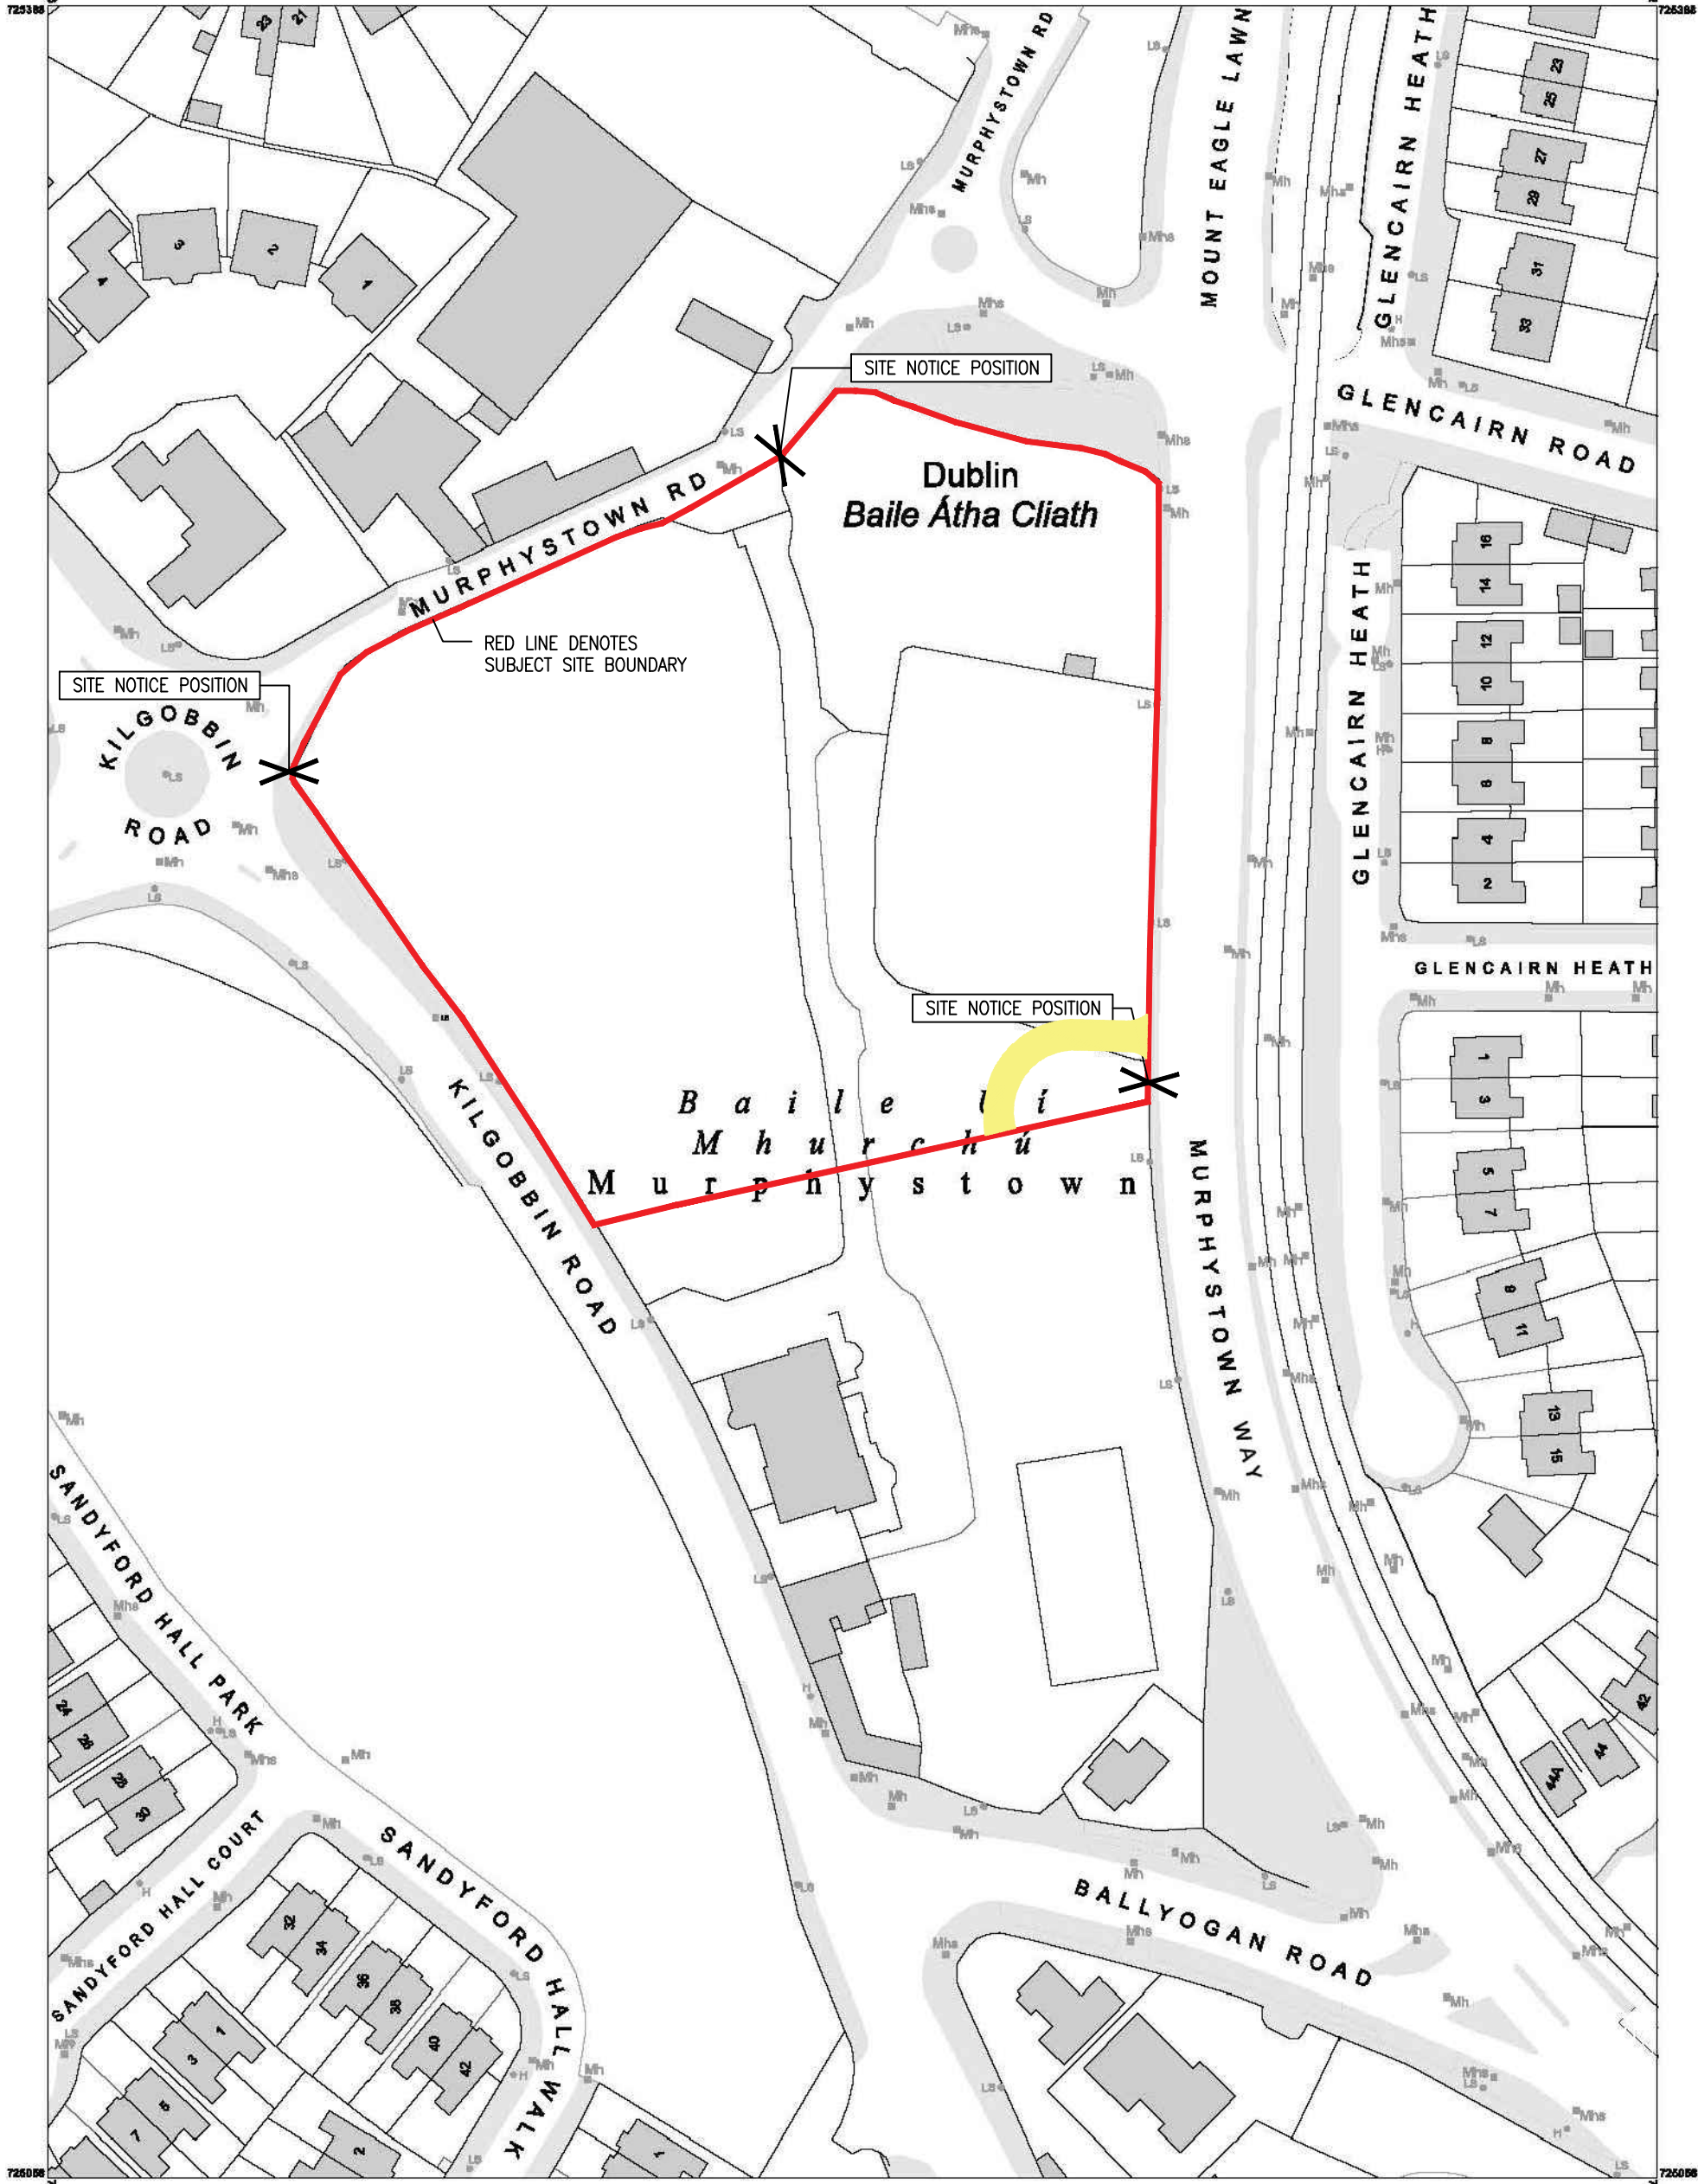

LEGEND

- RED LINE DENOTES SUBJECT SITE BOUNDARY
- SITE NOTICE POSITION
- WAYLEAVE SHOWN HATCHED YELLOW

SITE AREA

SITE AREA - 11967M2 (1.19 ha)

BKD LICENCE NO. CYAL50322051 (O.S. SHEET NUMBERS: 3455-10)

COMPILED AND PUBLISHED BY:
Ordnance Survey Ireland,
Phoenix Park,
Dublin 8,
Ireland.

All rights reserved.
No part of this publication may be copied, reproduced or transmitted in any form or by any means without the prior written permission of the copyright owners.

Ordnance Survey maps never show legal property boundaries, nor do they show ownership of physical features.

MAP SERIES:
1:1,000

CENTRE COORDINATES:
ITM 719289,725222

ORDER NO.: 50028544_1
PUBLISHED: 08/10/2018
©Suirbhéireacht Ordánais Éireann, 2018
©Ordnance Survey Ireland, 2018
www.osi.ie/copyright

MAP SHEETS:
3455-10

CAPTURE RESOLUTION:
The map objects are only accurate to the resolution at which they were captured. Output scale is not indicative of data capture scale. Further information is available at: <http://www.osi.ie>; search 'Capture Resolution'

LEGEND:
<http://www.osi.ie>; search 'Large Scale Legend'



Issue Status	No.	Date	Revision	Init.
Progress	P01	06.10.23	Planning App	MG
Planning Application				
Fire Cert				
Disability Cert				
Tender				
Construction				
As Built				
Information Only				

M:\Project Section - Current\6275 Lisieux Hall\CAD\Planning\06 General Amendments Application\GIS-BKD-ZZ-ZZ-M2-A-0001 Site Location Map.dwg 04/10/2023 15:37:33

Project	Drawing Title	Stage	Scale	Drawn	Apd	FF	Date
RESIDENTIAL APARTMENTS, LISIEUX PARK Murphystown Road, Leopardstown, Dublin 18	SITE LOCATION MAP	PLANNING	1:1000@A2	MG			14.02.23
Project Code 6275	Job LIS	origin - BKD	zone - ZZ	level - ZZ	type - DR	dis - A	sheet no. 0001
							status P3
							rev P01

6-7 HARCOURT TERRACE, DUBLIN 2, IRELAND
t +353-1-618 2400 f +353-1-618 7366
e architecture@bkd.ie
www.bkd.ie

bkdarchitects
BURKE-KENNEDY DOYLE