


PERMITTED
SECOND FLOOR


Notes		Issue Status		No.		Date		Revision		Initials	
1. Copyright Reserved		Progress		P01		06.10.2023		Planning Permission Application - General Amendments		MG	
2. Work to figured dimensions only. Do not scale drawing.		Planning Application									
3. The contractor is responsible for checking all levels and dimensions on site and shall refer all discrepancies to the Architect		Fire Cert									
4. Where appropriate, for details of r.c. structure, or mechanical and electrical details, see Engineers drawings		Disability Cert									
5. Proprietary items shall be fixed in strict accordance with manufacturers instructions.		Tender									
6. Sizes of proprietary items shall be checked with manufacturer.		Construction									
7. The contractor shall be responsible for the coordination of structure, finishes and services.		As Built									
M:\Project Section - Current\6275 Lisieux Hall\CAD\Planning\06 General Amendments Application\Permitted Plans\Second Floor Plan.dwg		Information Only									
12/10/2023 15:29:26											

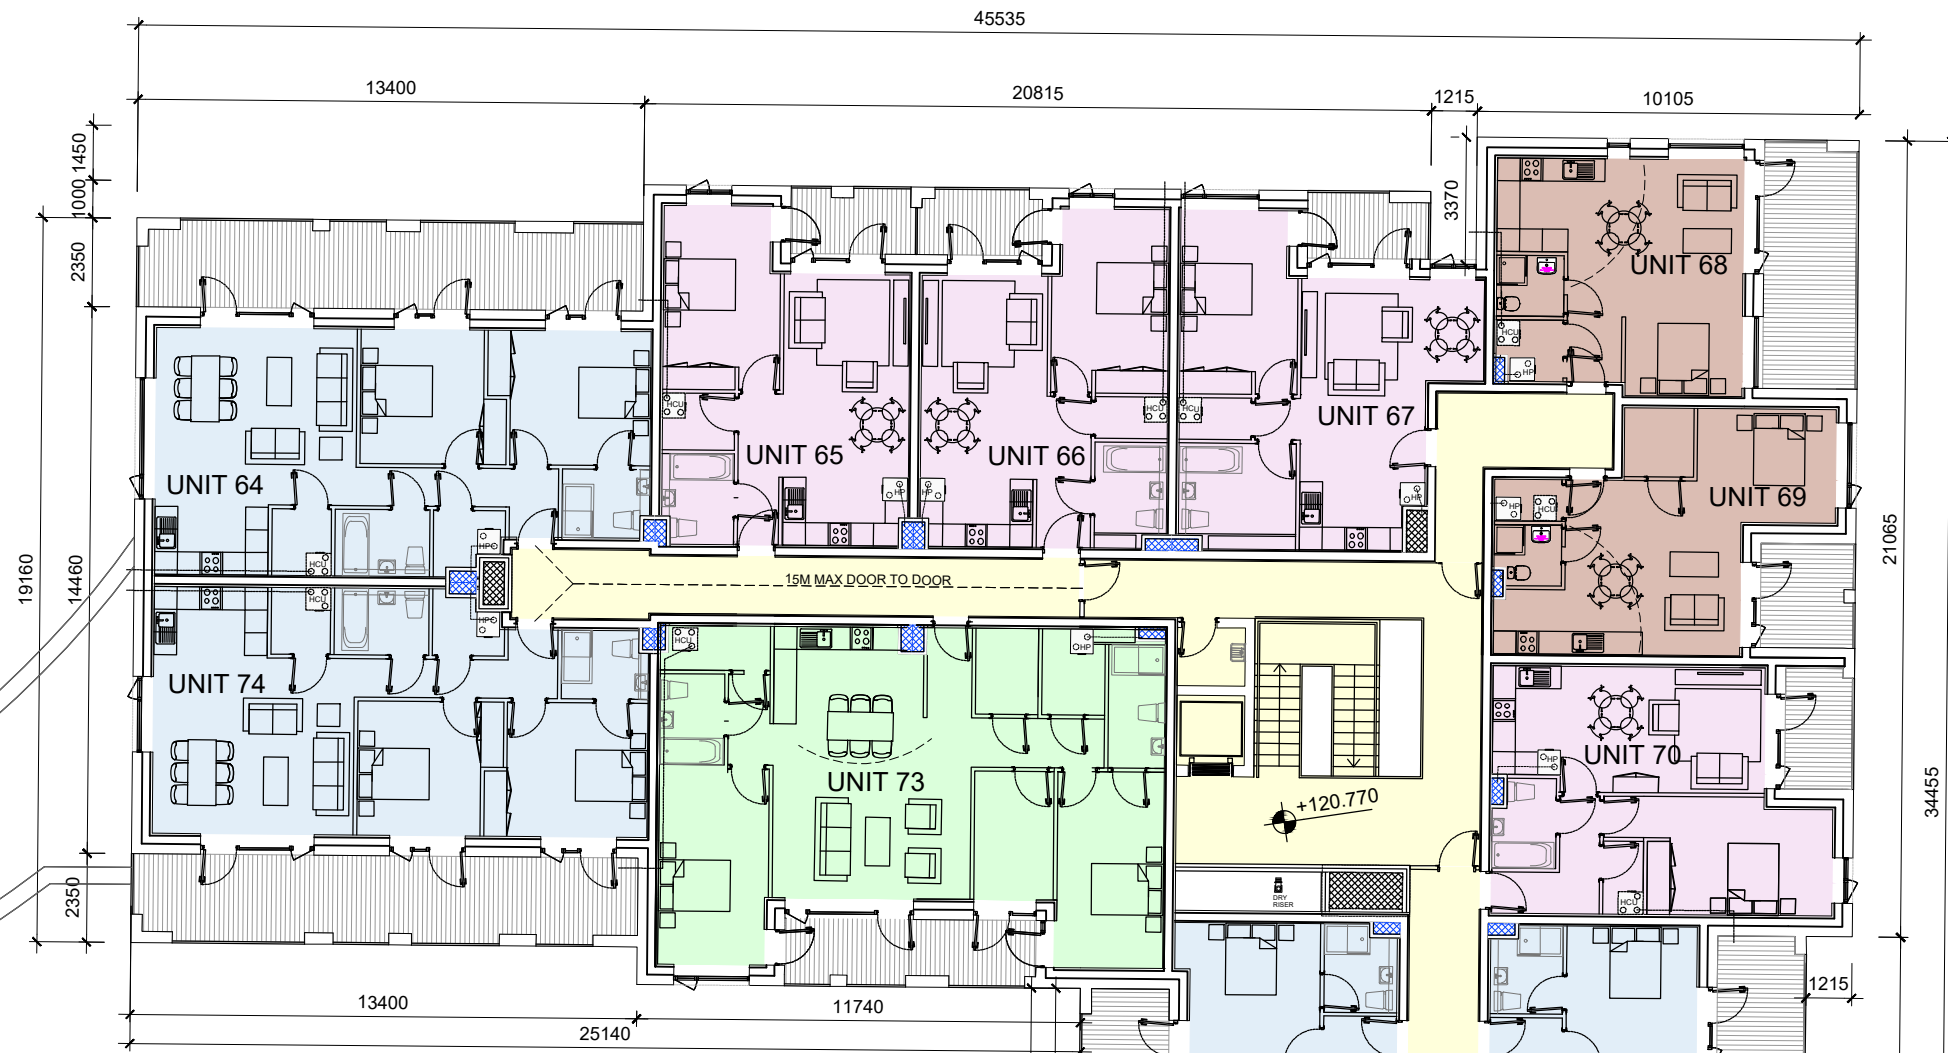


BLOCK 3



BLOCK 1

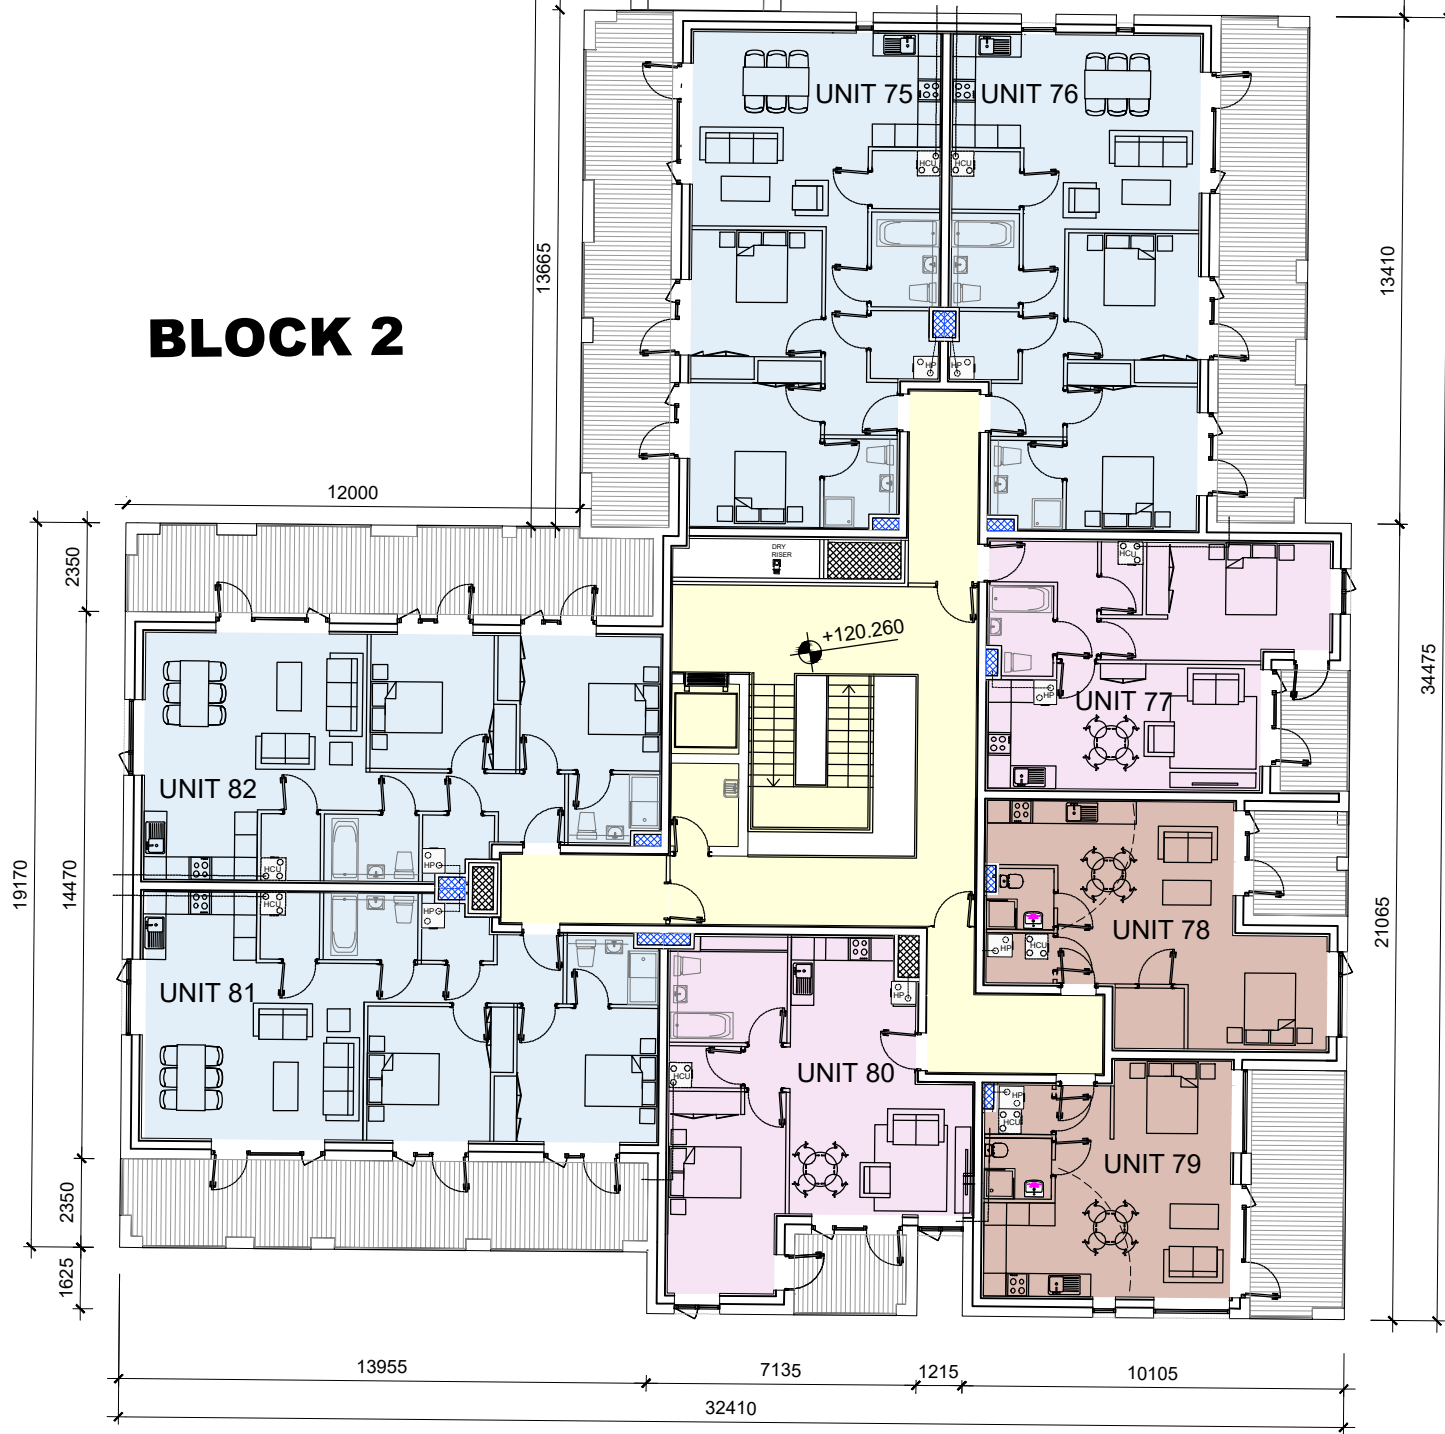


BLOCK 2

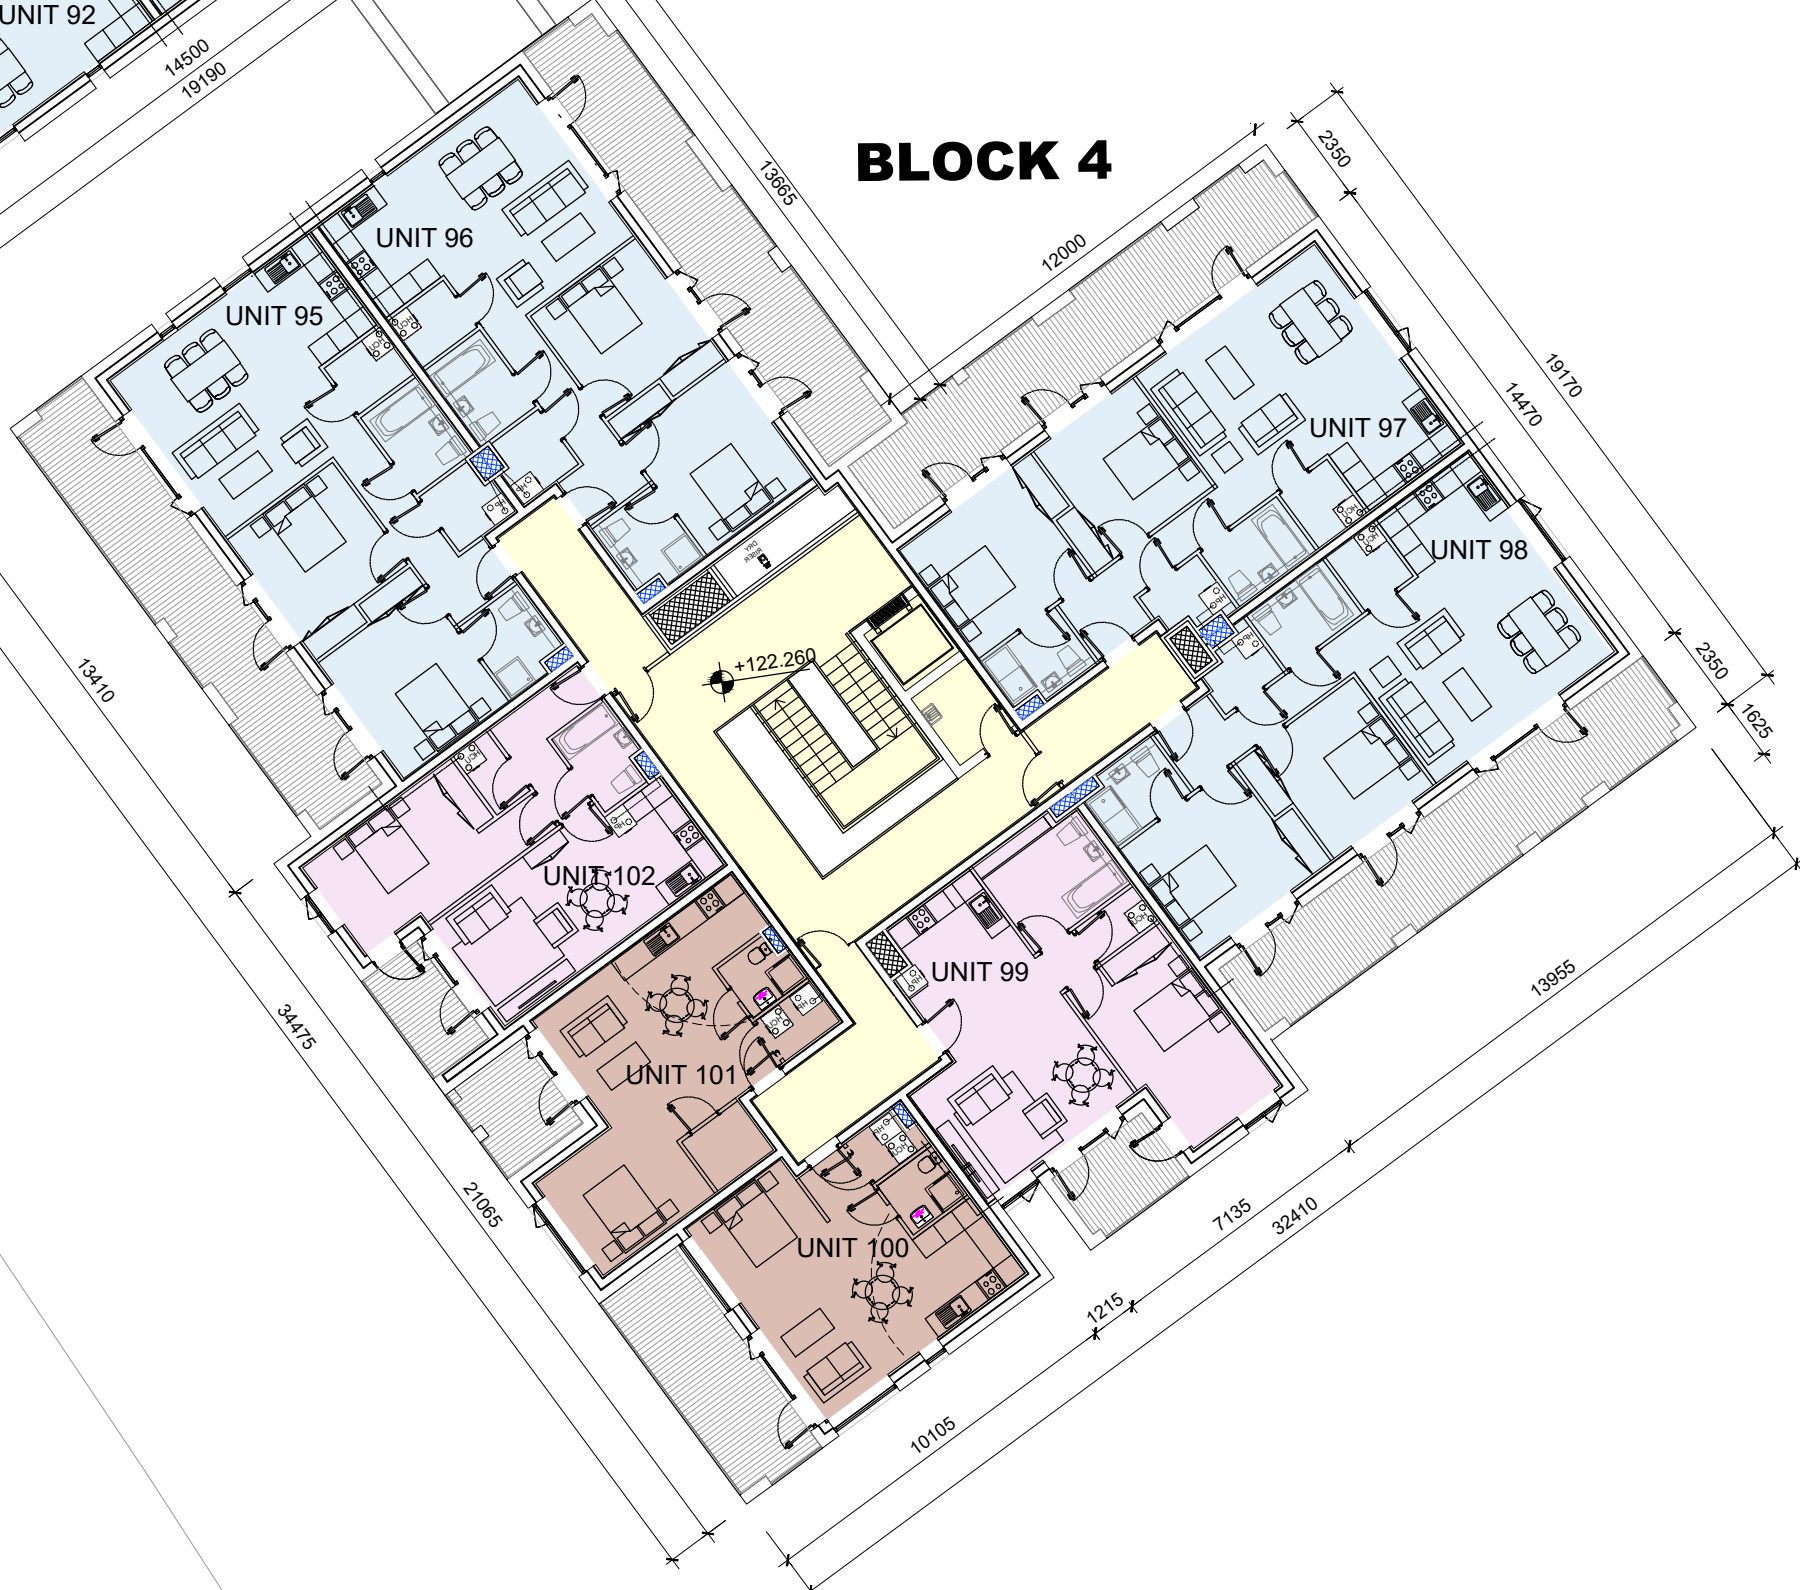

BLOCK 4

LEGEND:	
	1 BED STUDIO
	1 BED APARTMENT
	2 BED APARTMENT
	3 BED APARTMENT

LISIEUX PARK

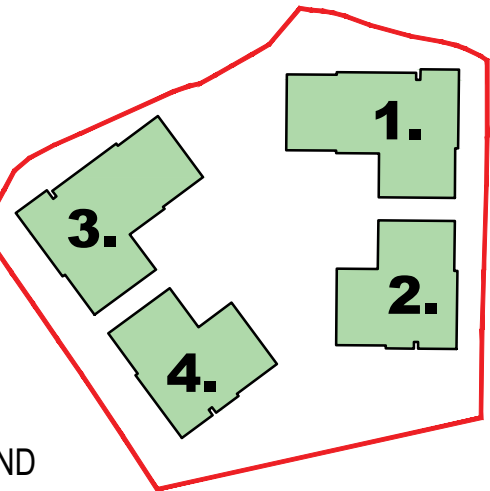

PERMITTED DRAWING FROM PLANNING APPLICATION AND
COMPLIANCE SUBMISSION REF. ABP-307415-20

Project		RESIDENTIAL APARTMENTS, LISIEUX PARK		6-7 HARDCOURT TERRACE, DUBLIN 2, IRELAND	
Drawing Title		Murphystown Road, leopoldstown, Dublin 18		1 + 363-1-618 2100 1 + 363-1-676 7385	
Stage		Planning		www.bkd.ie	
Scale		1:200@A1		bkdarchitects	
Drawn		MG		BURKE-KENNEDY DOYLE	
Apd		FF			
Date		03.04.2023			
Project Code		6275			
Job		LIS			
origin		BKD			
zone		00			
level		02			
type		DR			
dis		A			
sheet no.		0500			
status					
rev		P01			