

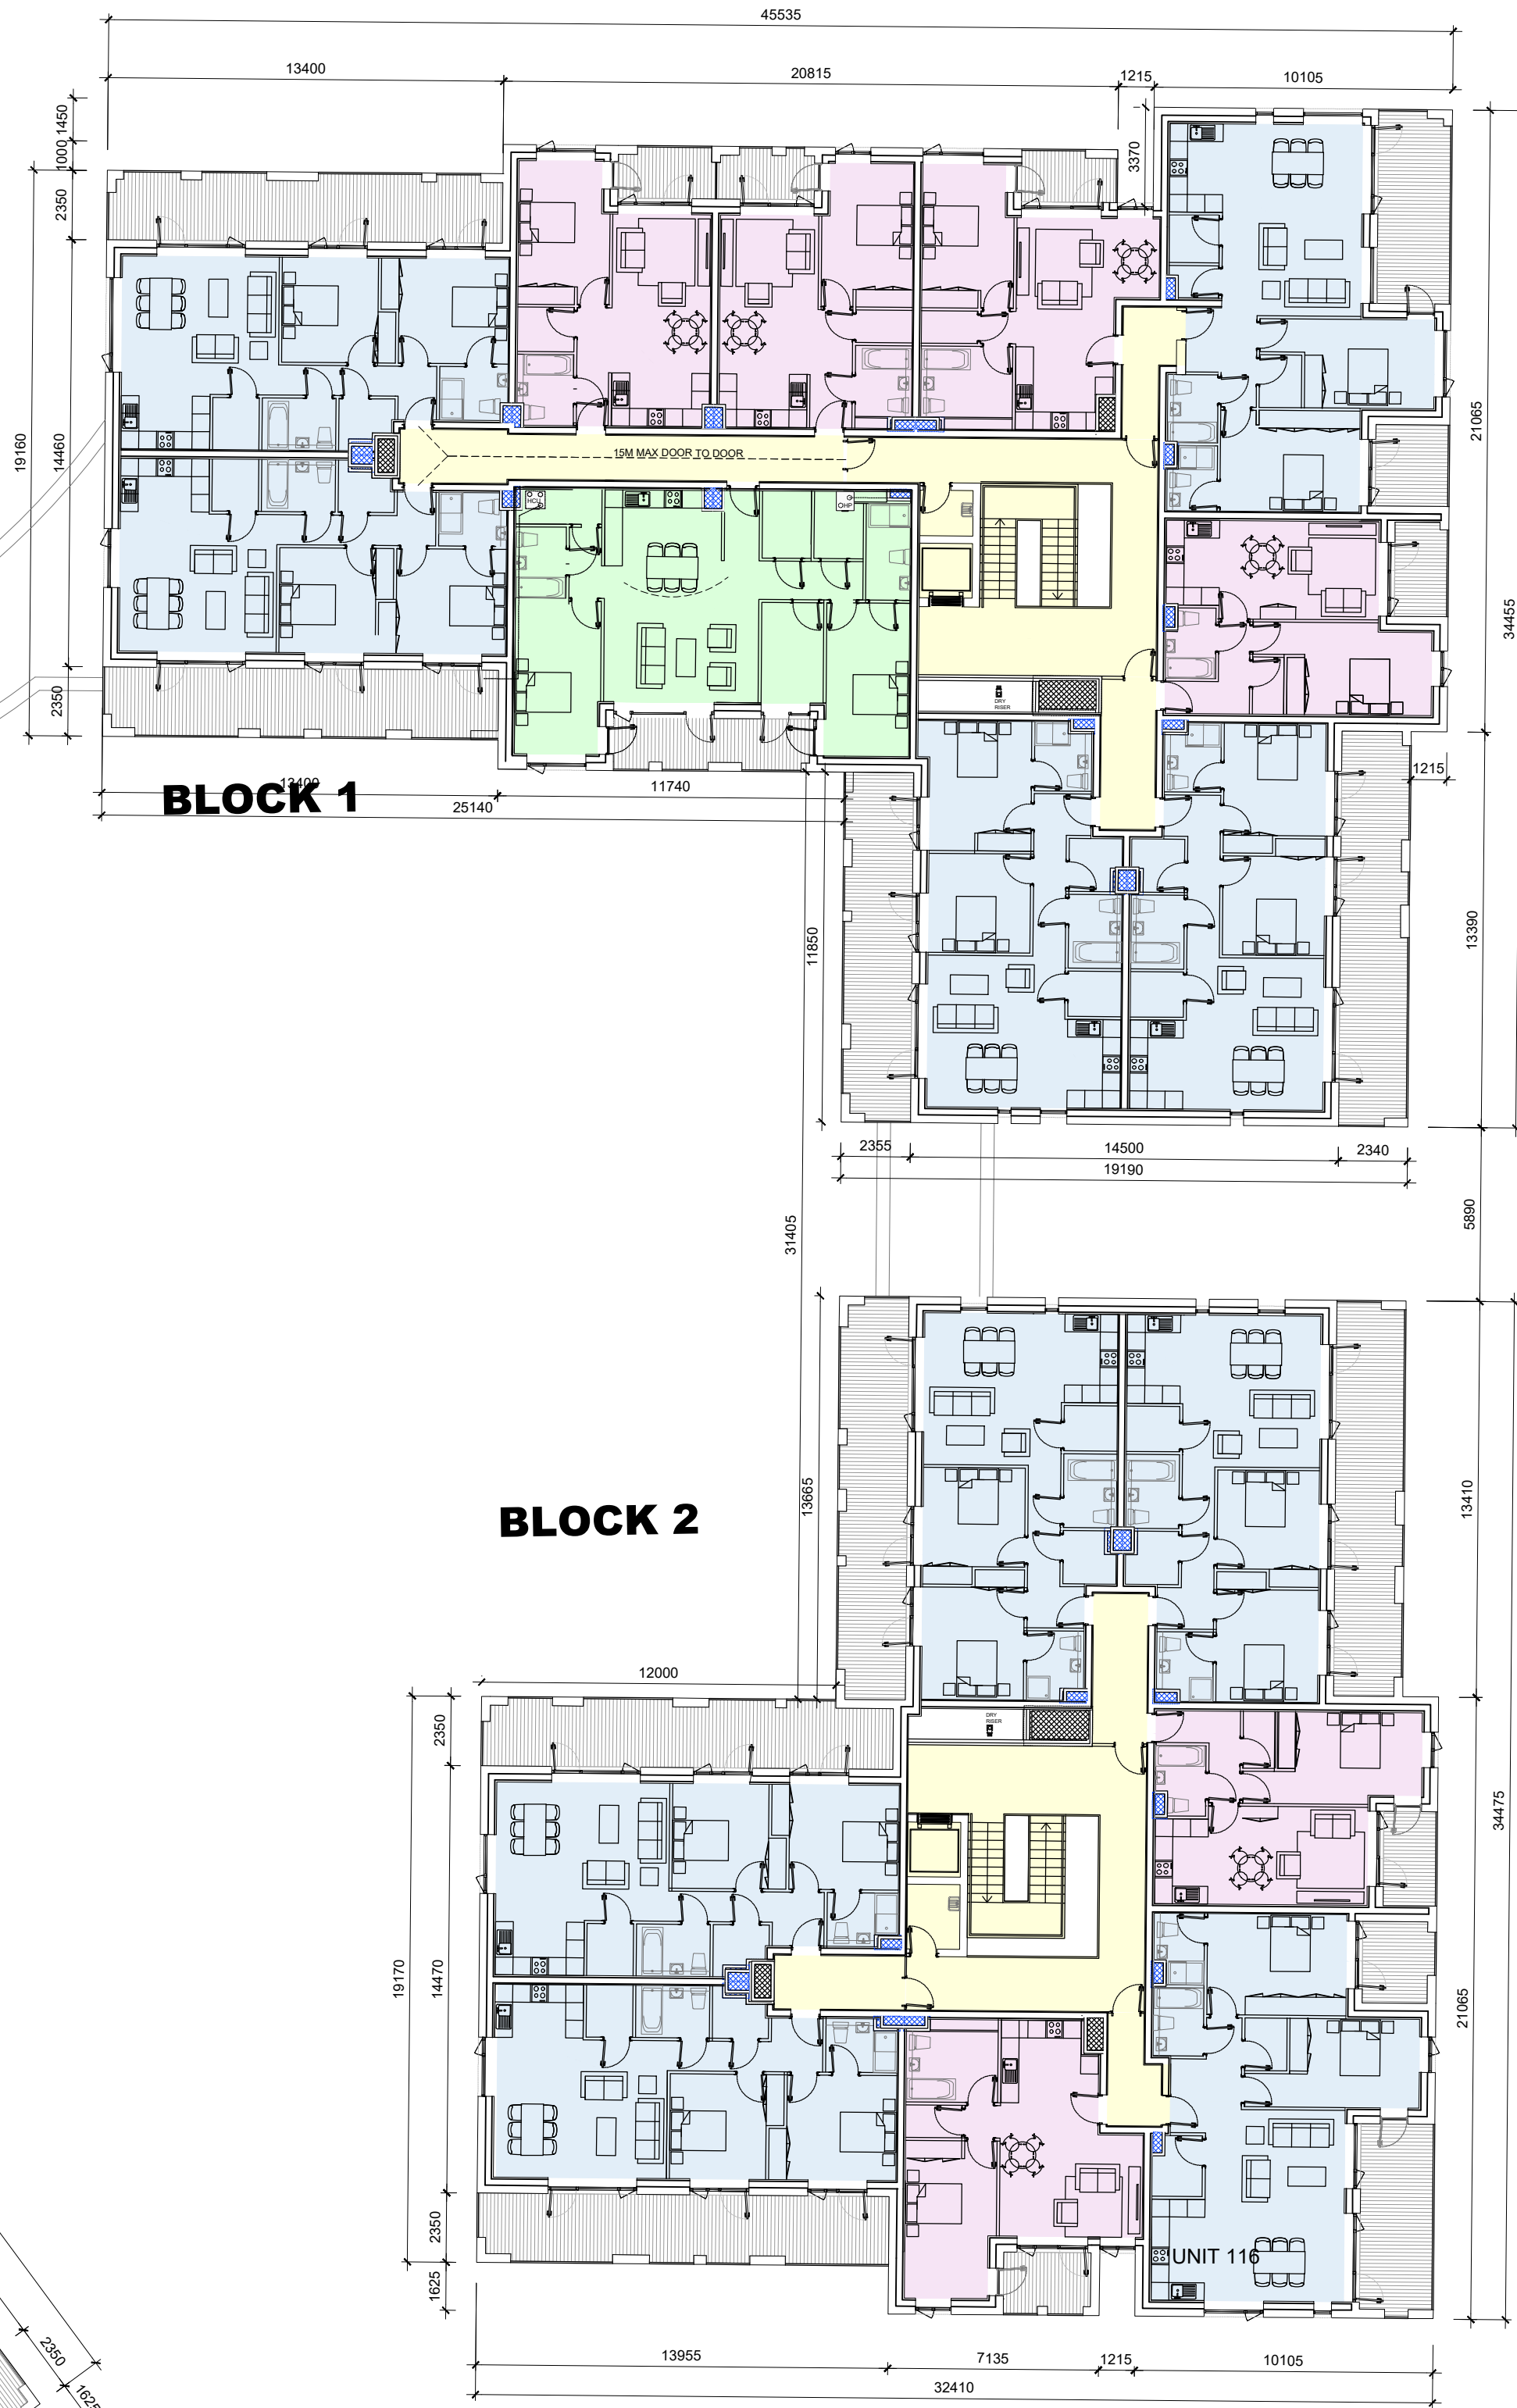


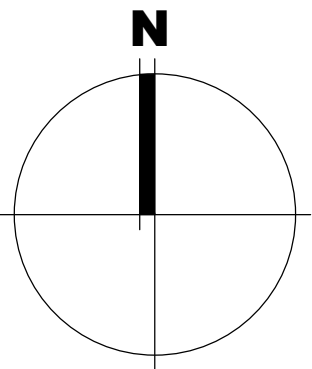

LEGEND:	
	1 BED STUDIO
	1 BED APARTMENT
	2 BED APARTMENT
	3 BED APARTMENT

PERMITTED
THIRD FLOOR

LISIEUX PARK

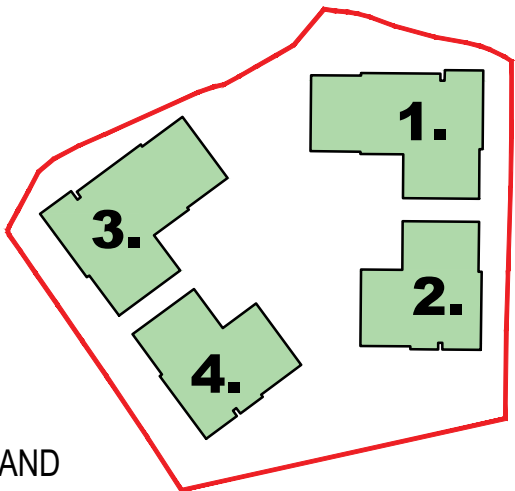

PERMITTED DRAWING FROM PLANNING APPLICATION AND
COMPLIANCE SUBMISSION REF. ABP-307415-20

Notes		Issue Status		No.		Date		Revision		Initials	
1. Copyright Reserved		Progress		P01		06.10.2023		Planning Permission Application - General Amendments		MG	
2. Work to figured dimensions only. Do not scale drawing.		Planning Application									
3. The contractor is responsible for checking all levels and dimensions on site and shall refer all discrepancies to the Architect		Fire Cert									
4. Where appropriate, for details of r.c. structure, or mechanical and electrical details, see Engineers drawings		Disability Cert									
5. Proprietary items shall be fixed in strict accordance with manufacturers instructions.		Tender									
6. Sizes of proprietary items shall be checked with manufacturer.		Construction									
7. The contractor shall be responsible for the coordination of structure, finishes and services.		As Built									
Information Only											

Project		6-7 HARDCOURT TERRACE, DUBLIN 2, IRELAND	
RESIDENTIAL APARTMENTS, LISIEUX PARK		1 + 303-1-818 2100 1 + 303-1-818 7385	
Murphystown Road, leopardsdown, Dublin 18		www.bkd.ie	
Drawing Title		Permitted Third Floor Plan	
Stage		Scale	
Planning		1:200@A1	
Project Code		Date	
6275		03.04.2023	
Job		Status	
LIS - BKD - 00 - 03 - DR - A - 500		P01	

bkdarchitects
BURKE-KENNEDY DOYLE