
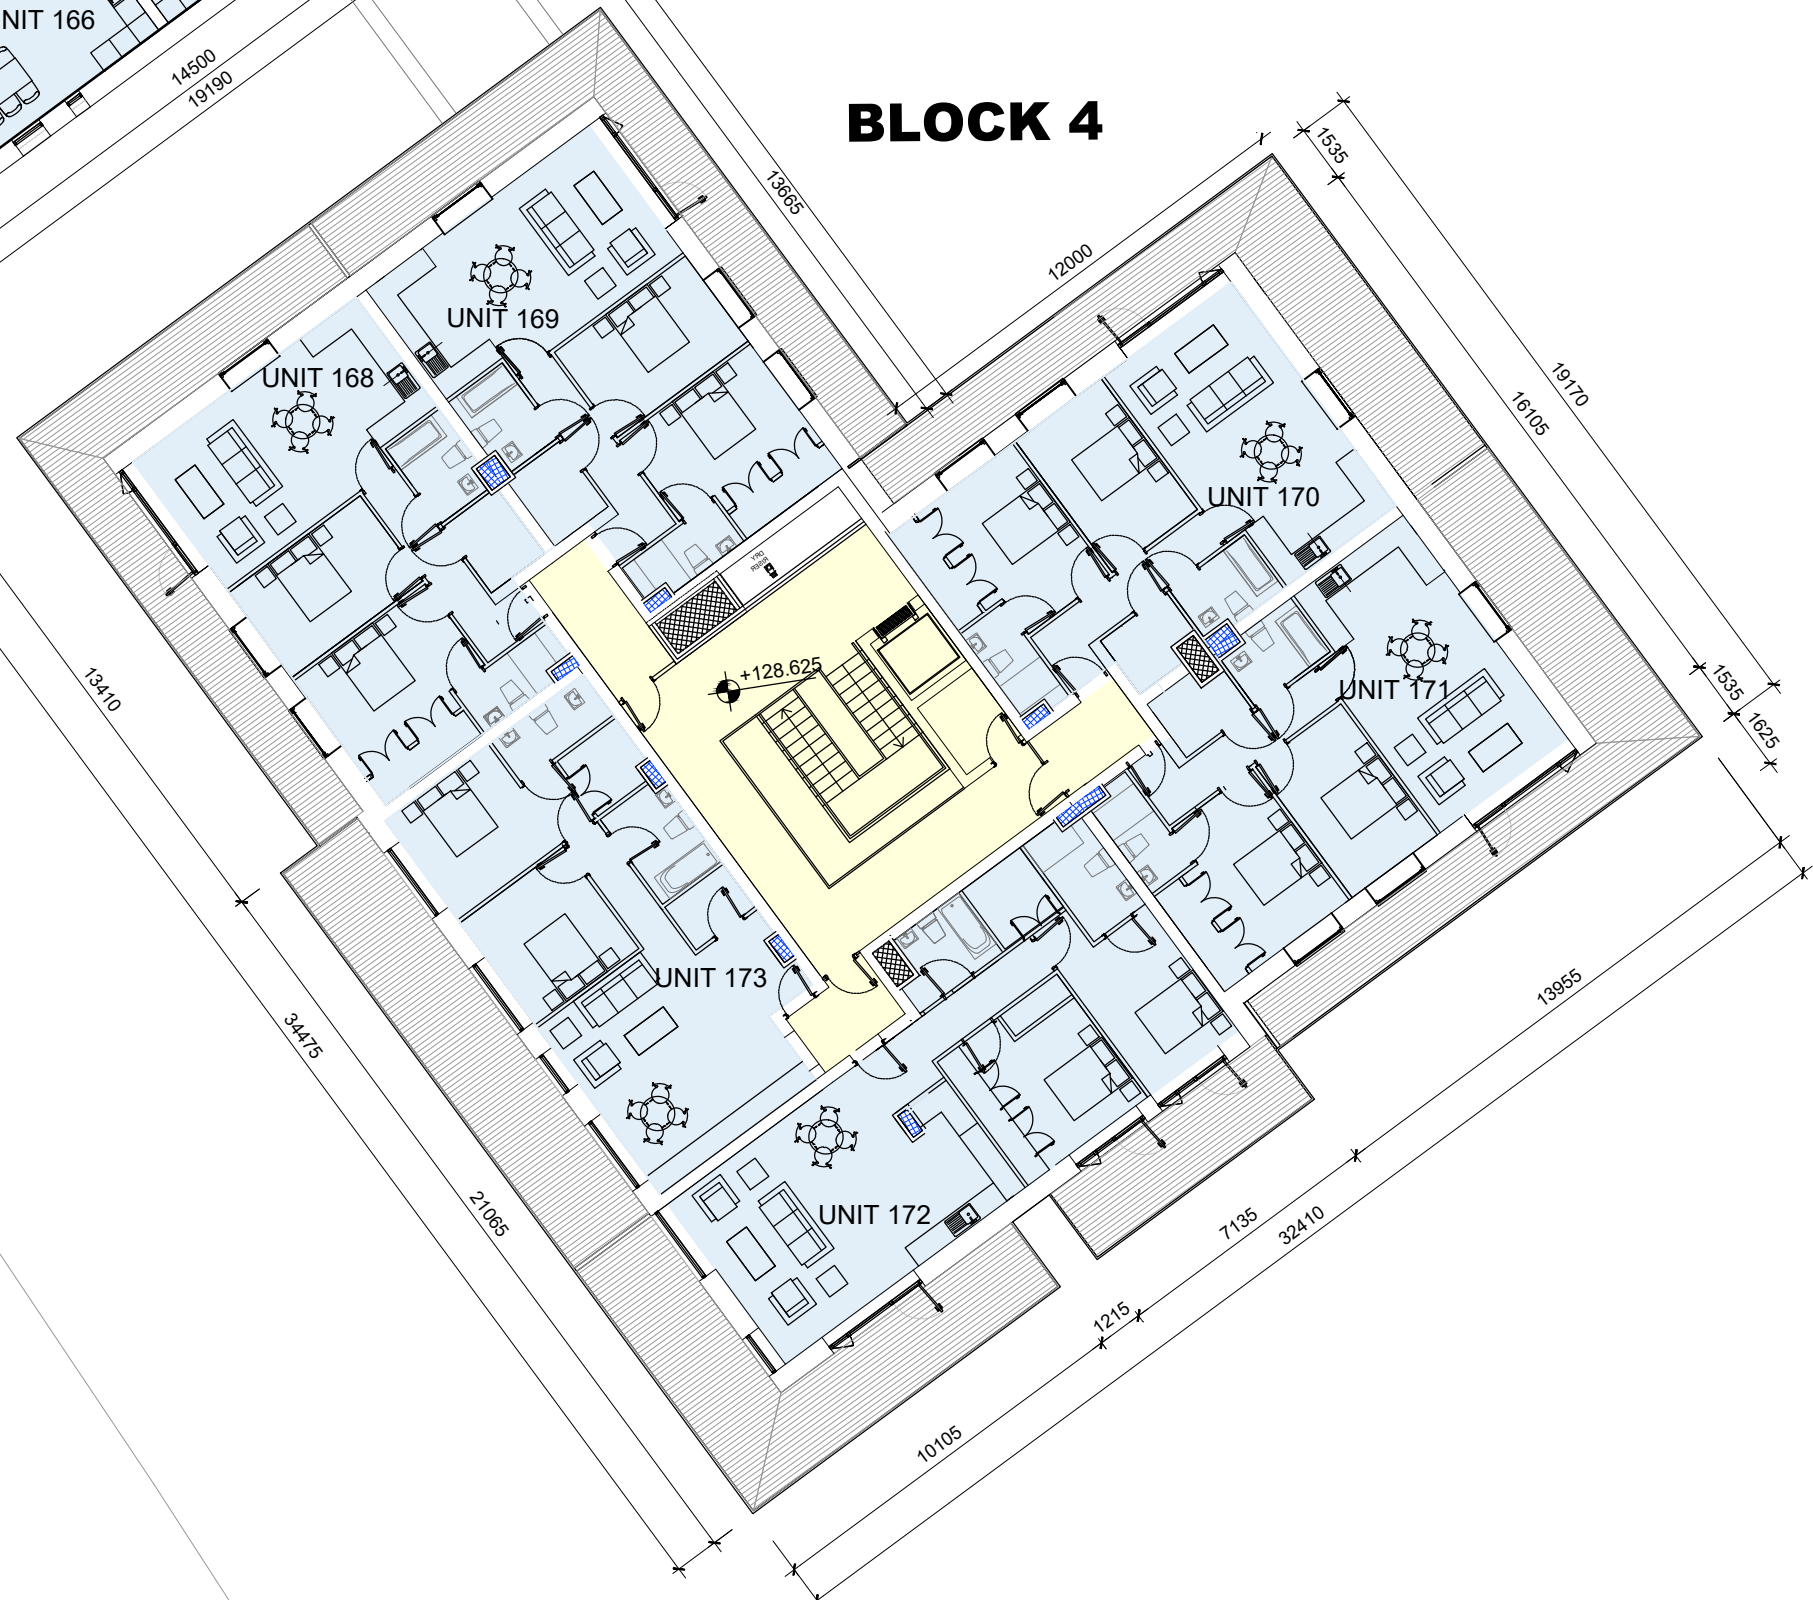



PERMITTED
FOURTH FLOOR

<div>Notes</div> <div>1. Copyright Reserved</div> <div>2. Work to figured dimensions only. Do not scale drawing.</div> <div>3. The contractor is responsible for checking all levels and dimensions on site and shall refer all discrepancies to the Architect</div> <div>4. Where appropriate, for details of r.c. structure, or mechanical and electrical details, see Engineers drawings</div> <div>5. Proprietary items shall be fixed in strict accordance with manufacturers instructions.</div> <div>6. Sizes of proprietary items shall be checked with manufacturer.</div> <div>7. The contractor shall be responsible for the coordination of structure, finishes and services.</div>	Issue Status									No.	Date	Revision	Initials
	Progress									P01	06.10.2023	Planning Permission Application – General Amendments	MG
	Planning Application												
	Fire Cert												
	Disability Cert												
	Tender												
	Construction												
	As Built												
	Information Only												
	M:\Project Section - Current\6275 Lisieux Hall\CAD\Planning\06 General Amendments Application\Permitted Plans\Fourth Floor Plan.dwg, 12/10/2023 15:38:22												

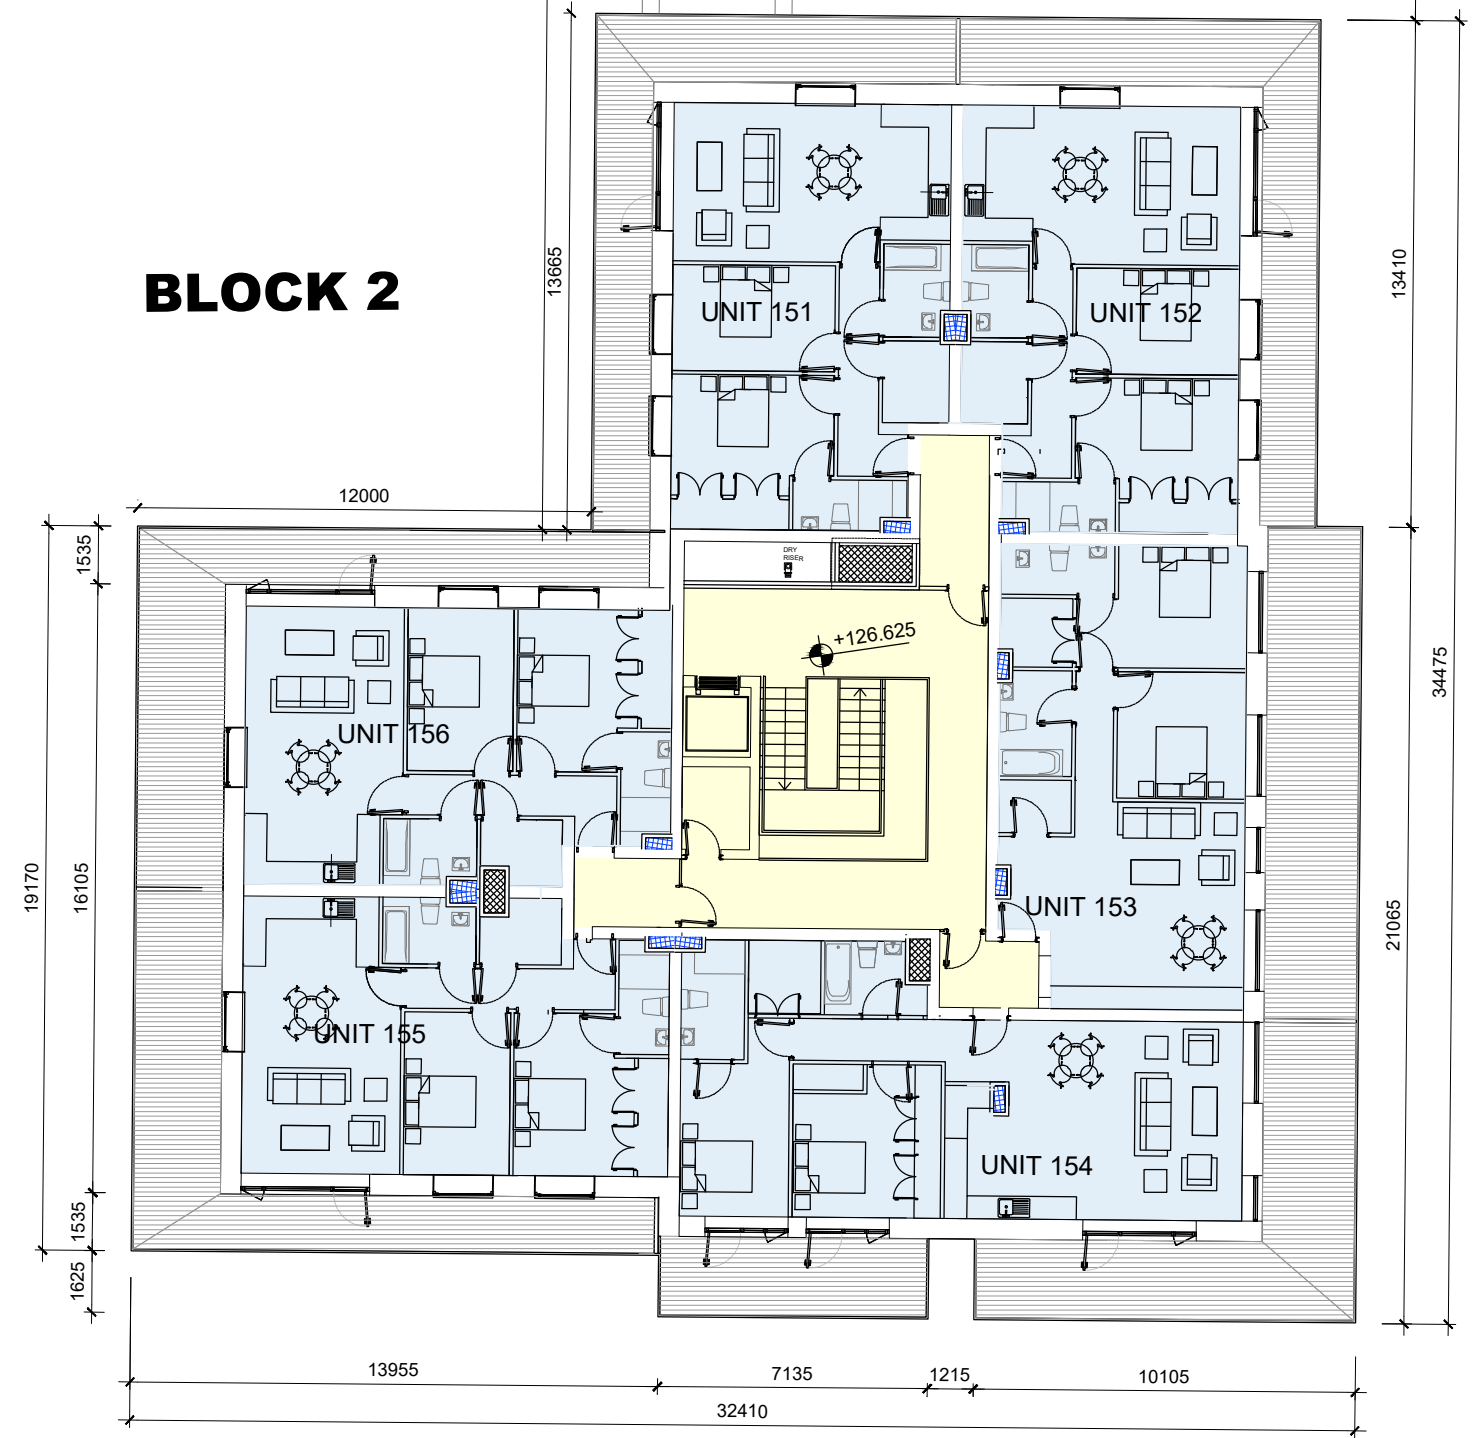

LEGEND:	
	1 BED STUDIO
	1 BED APARTMENT
	2 BED APARTMENT
	3 BED APARTMENT

LISIEUX PARK

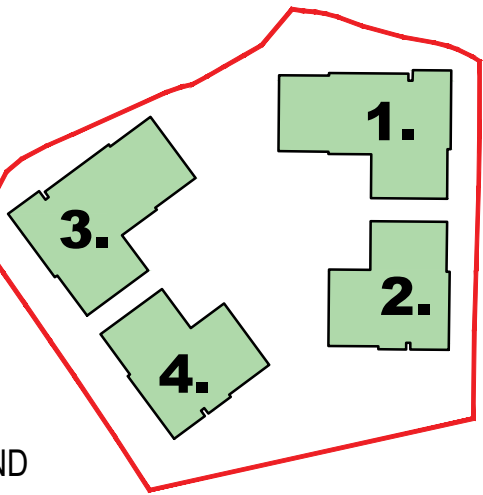

PERMITTED DRAWING FROM PLANNING APPLICATION AND
COMPLIANCE SUBMISSION REF. ABP-307415-20

Project										RESIDENTIAL APARTMENTS, LISIEUX PARK Murphystown Road, leopoldstown, Dublin 18										6-7 HARDCOURT TERRACE, DUBLIN 2, IRELAND t + 353-1-878 2100 f + 353-1-878 7385 e architecture@bkd.ie www.bkd.ie											
Drawing Title										Permitted Fourth Floor Plan										<div>bkdarchitects</div> <div>BURKE-KENNEDY DOYLE</div>											
Stage		Scale		Drawn		MG		Apd		FF		Date		03.04.2023																	
Planning		1:200@A1																													
Project Code		job		origin		zone		level		type		dis		sheet no.		status		rev													
6275		LIS		BKD		-00		-04		-DR		-A-		500				P01													