




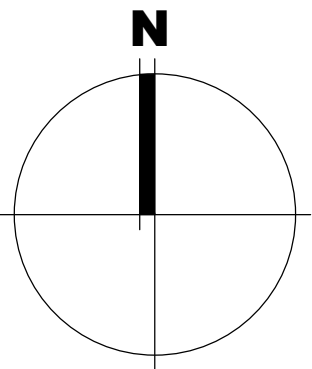


BLOCK 3

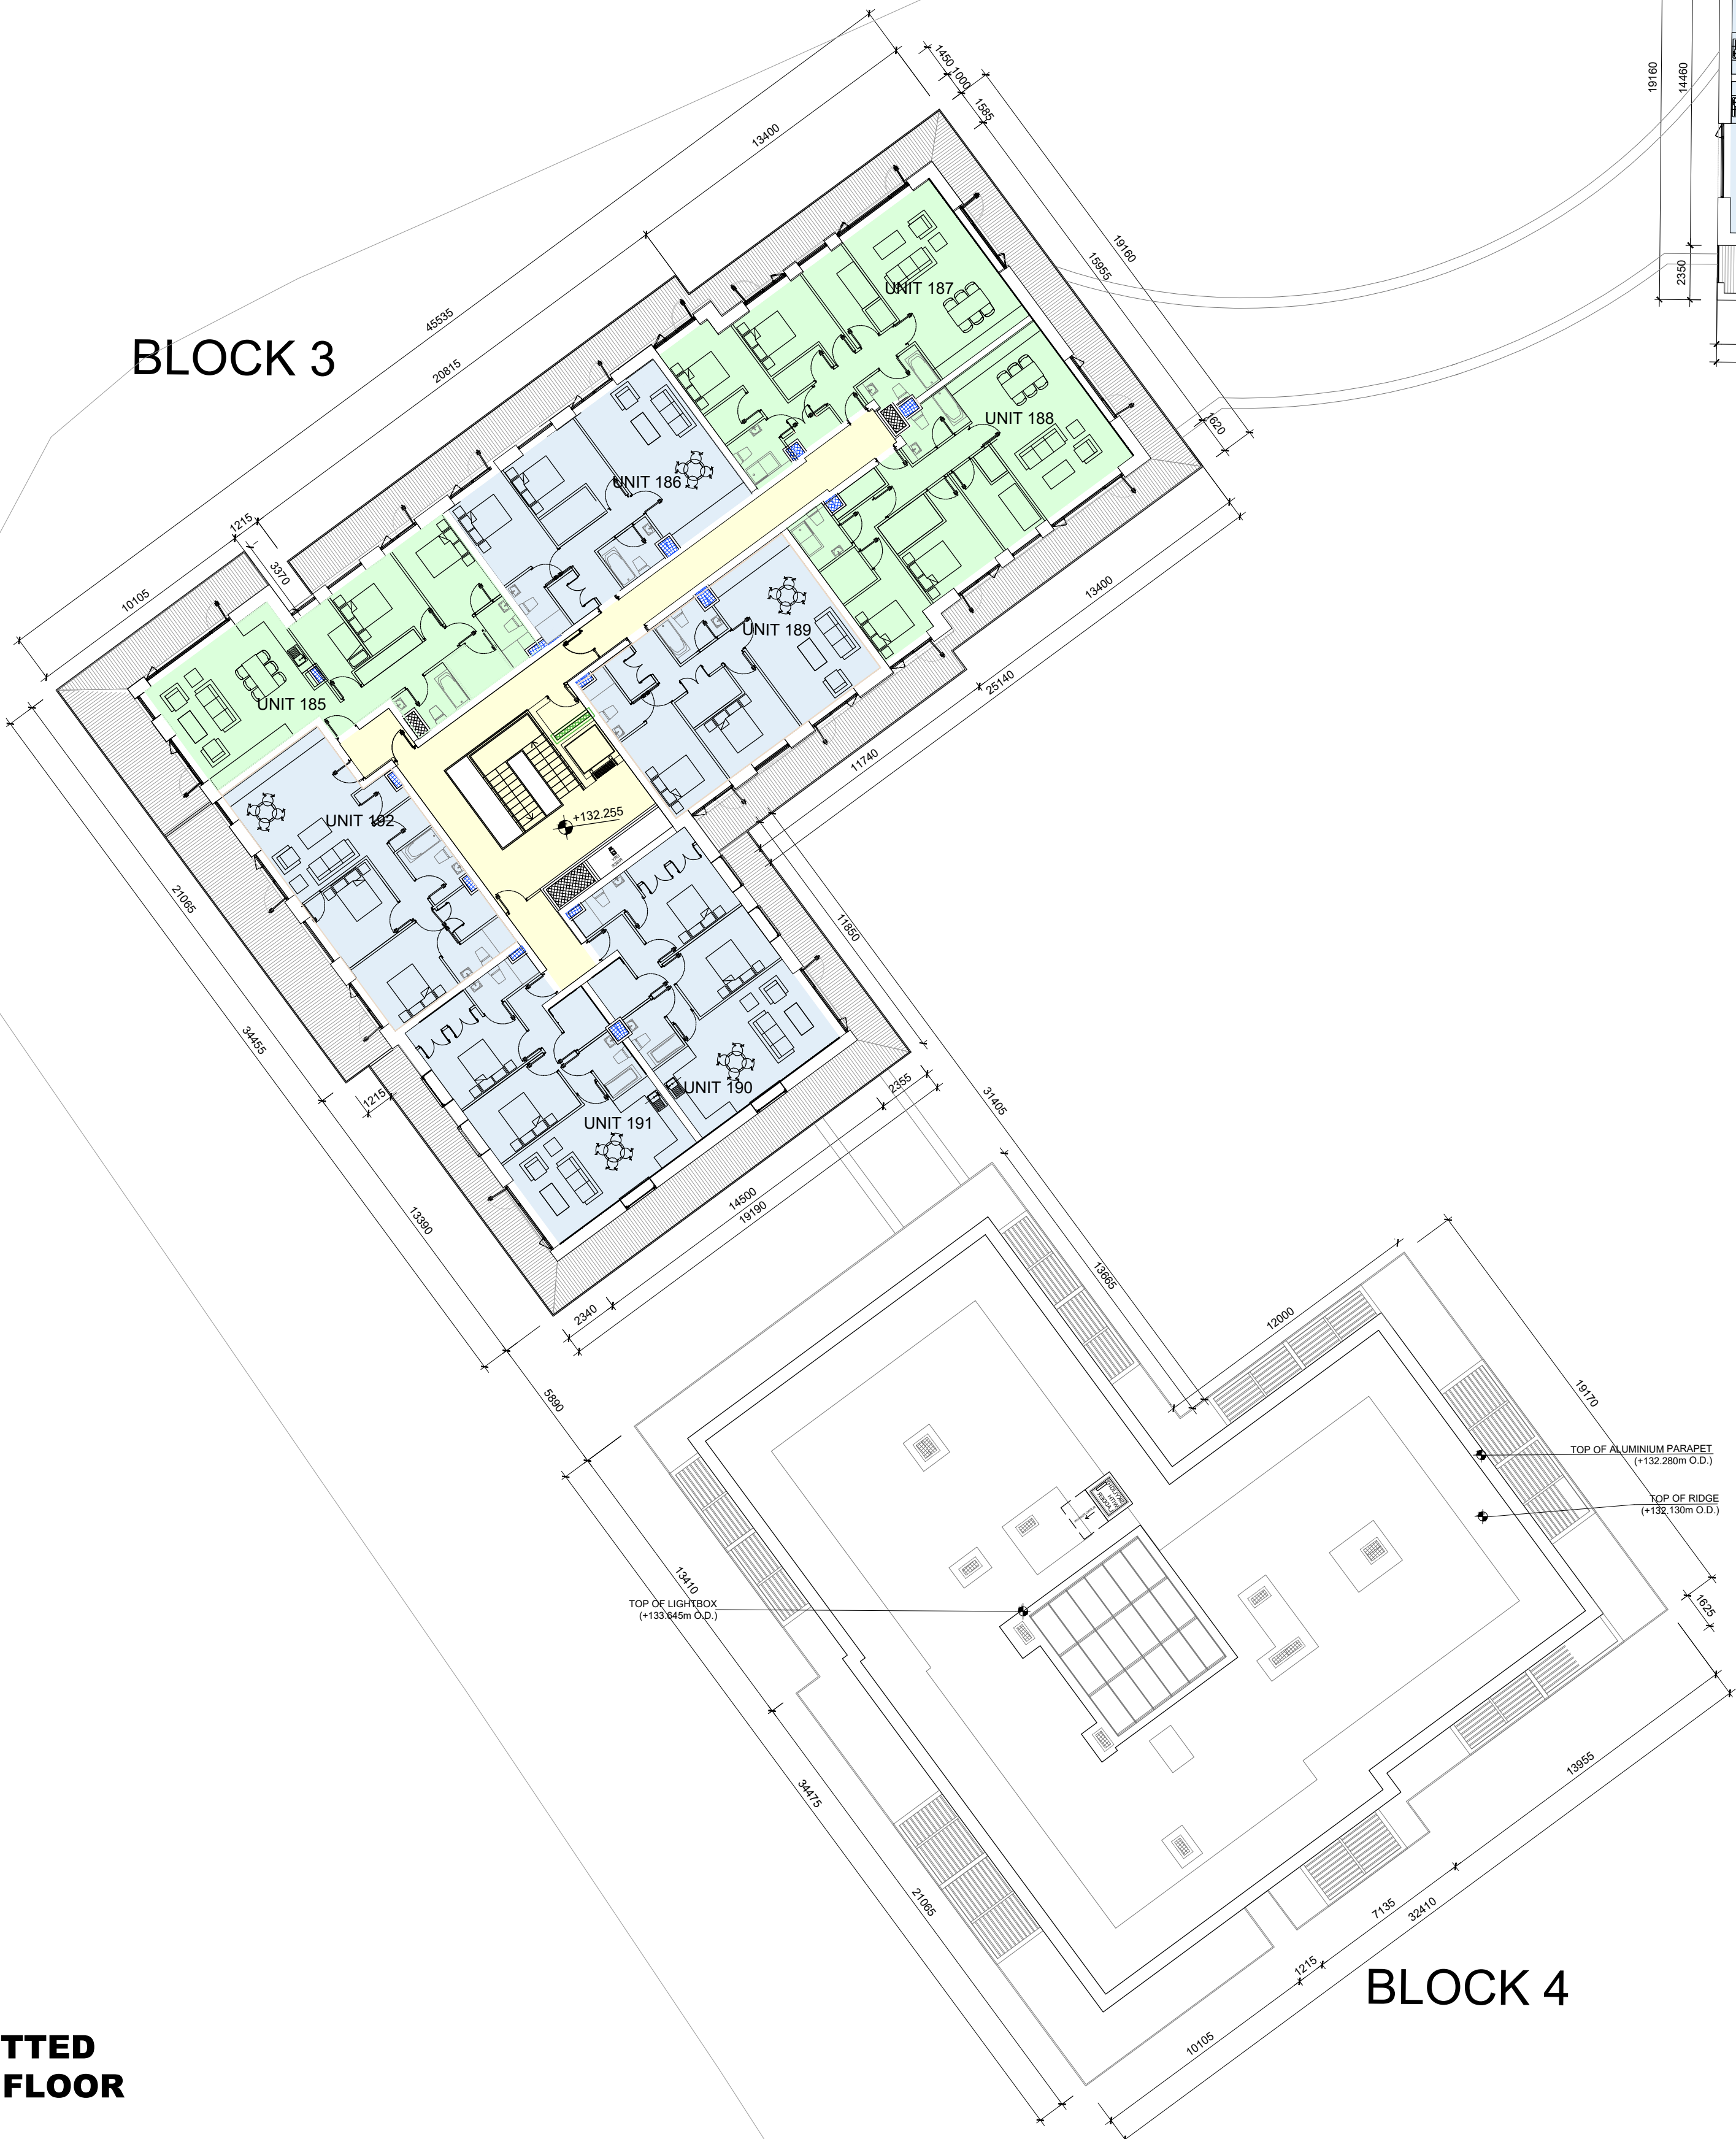

BLOCK 1

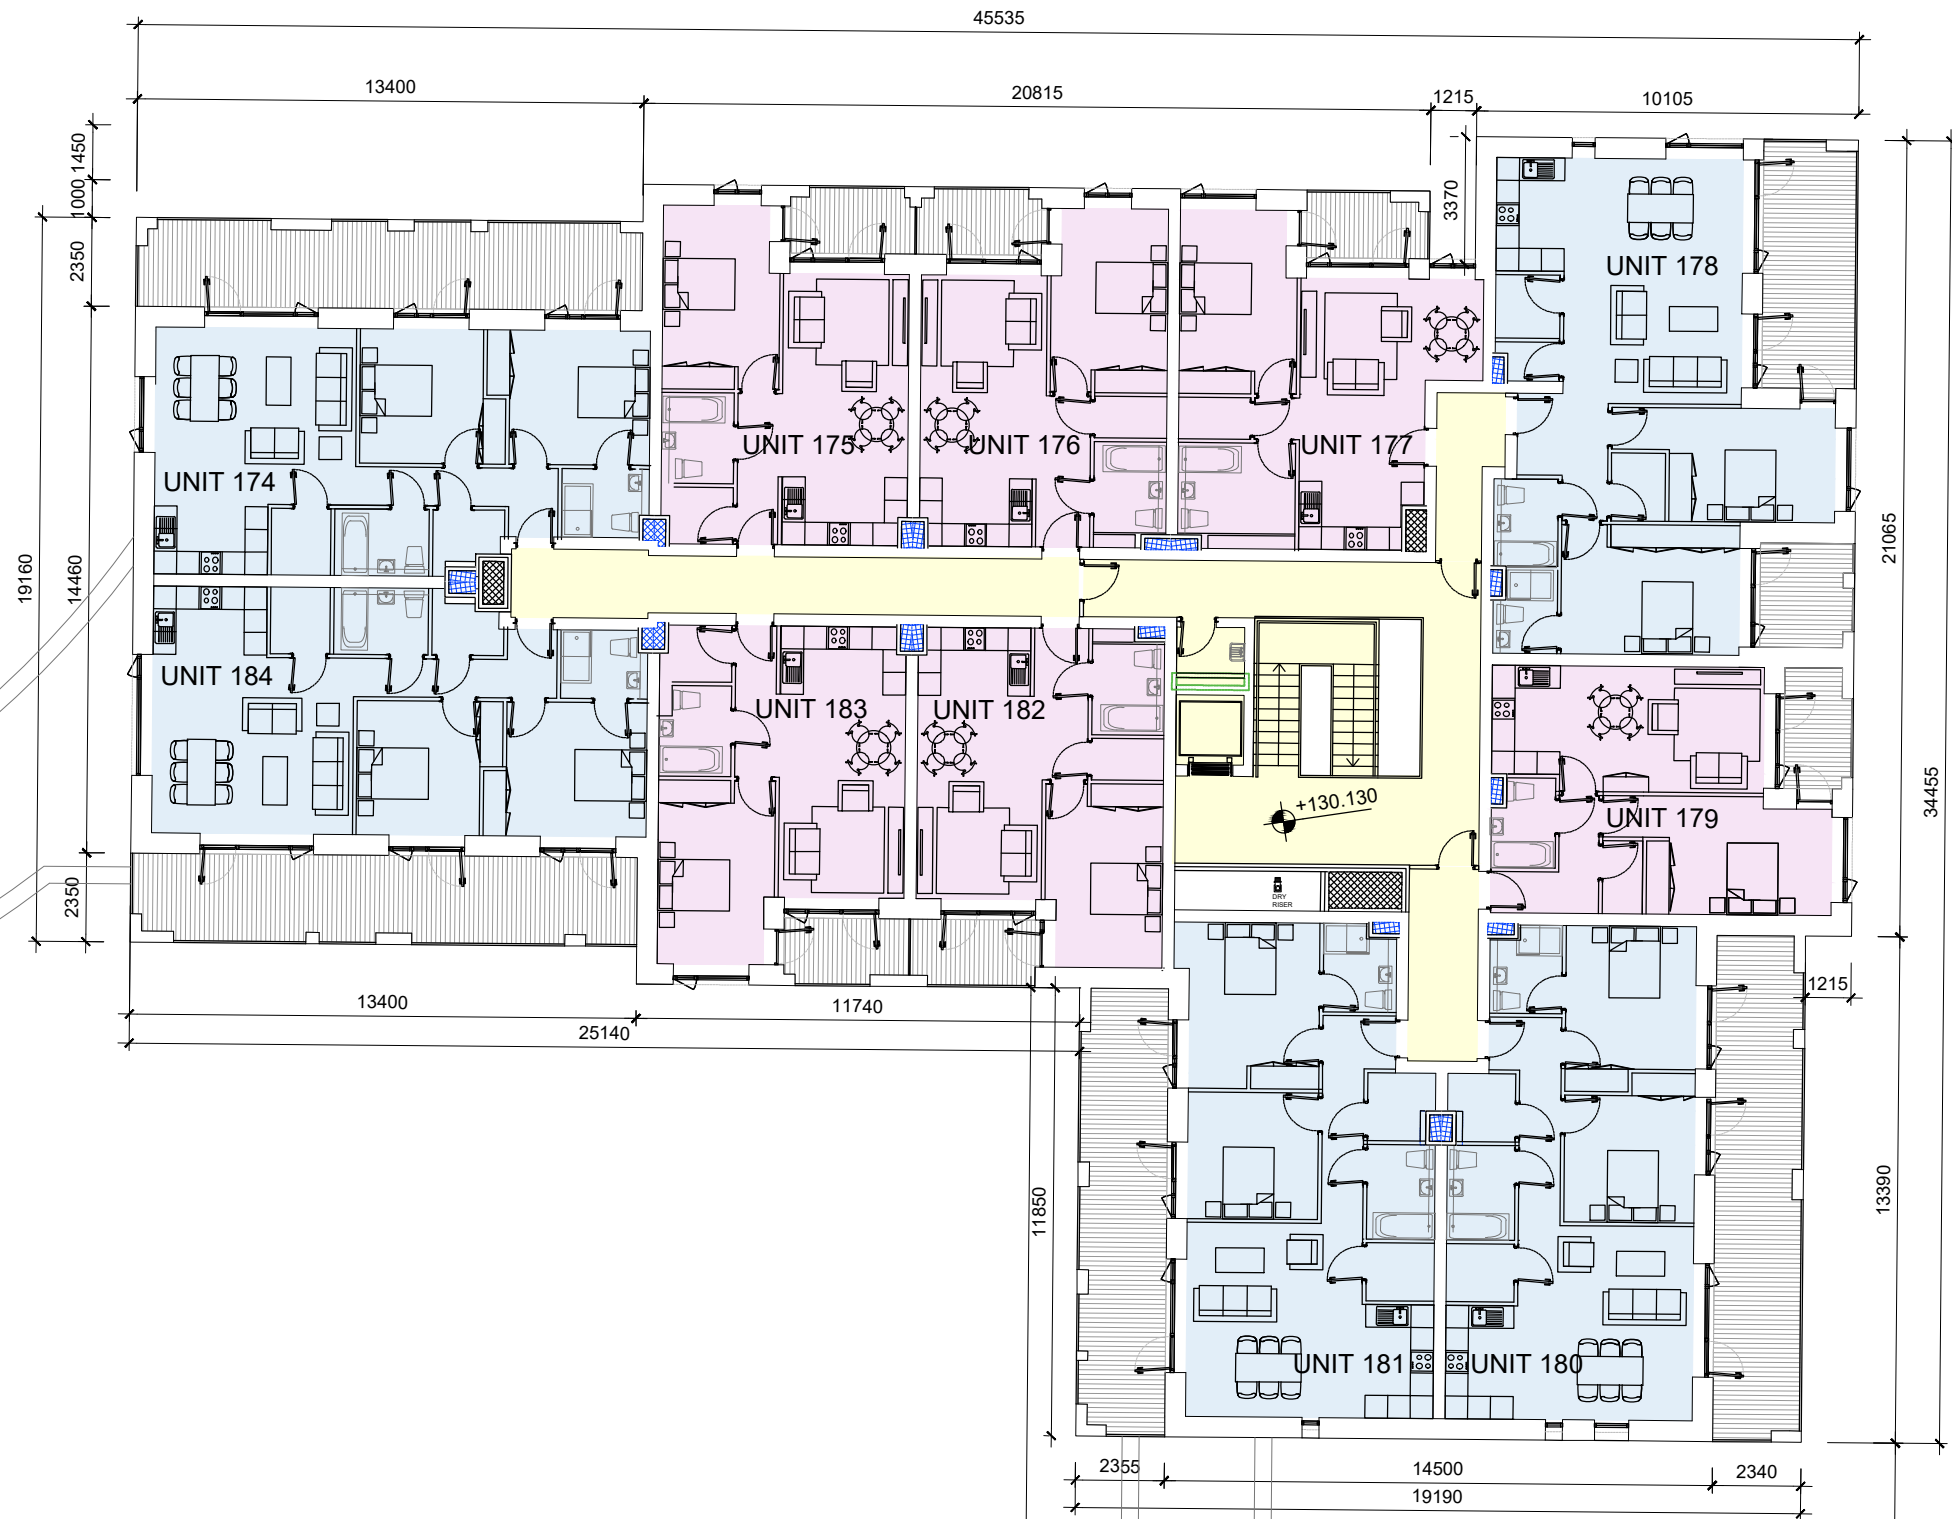

BLOCK 2

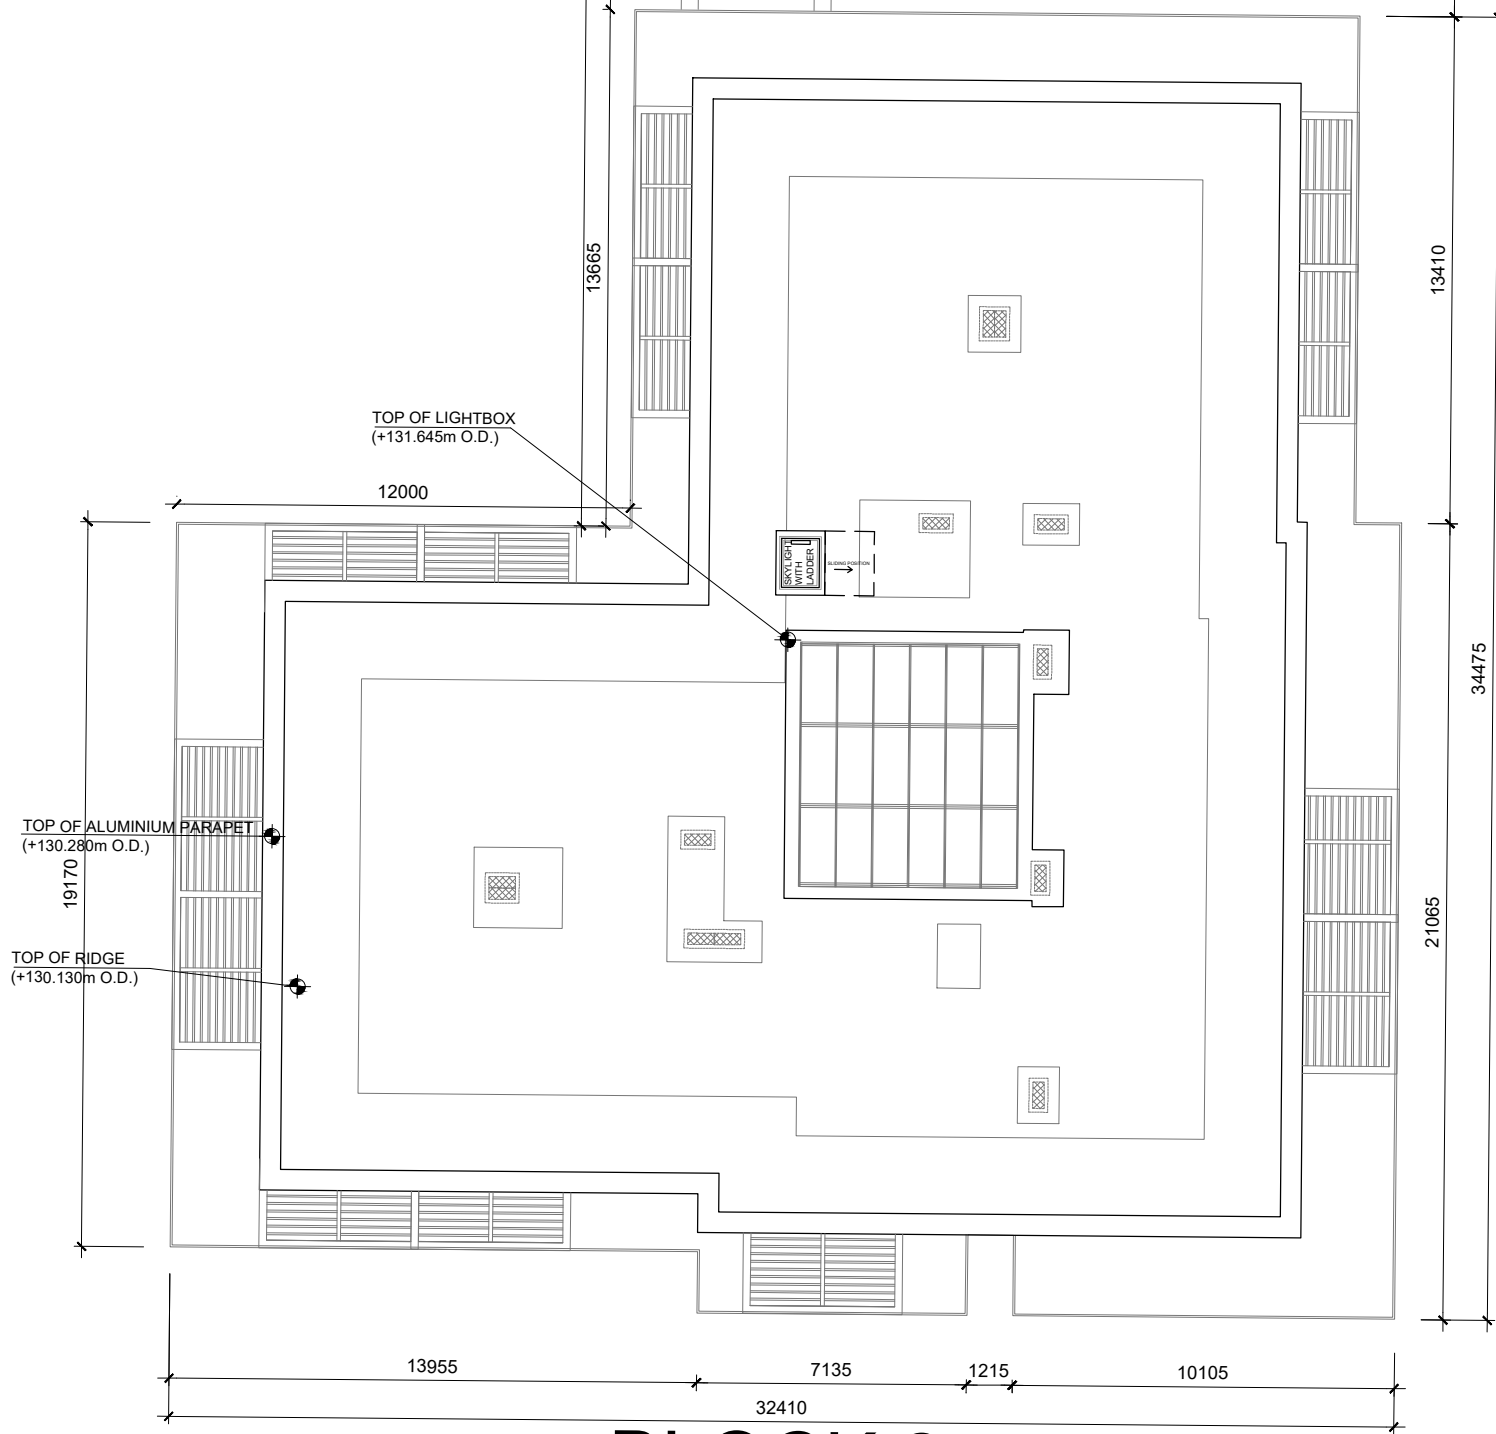


BLOCK 4

LEGEND:

- 1 BED STUDIO
- 1 BED APARTMENT
- 2 BED APARTMENT
- 3 BED APARTMENT

LISIEUX PARK

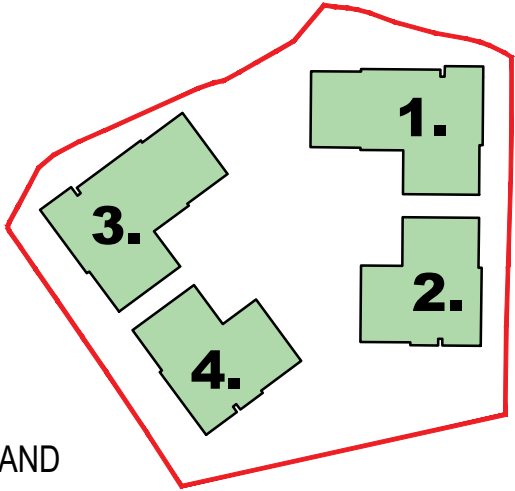

PERMITTED
FIFTH FLOOR

Notes		Issue Status		No.		Date		Revision		Initials	
1. Copyright Reserved		Progress		P01		06.10.2023		Planning Permission Application - General Amendments		MG	
2. Work to figured dimensions only. Do not scale drawing.		Planning Application									
3. The contractor is responsible for checking all levels and dimensions on site and shall refer all discrepancies to the Architect		Fire Cert									
4. Where appropriate, for details of r.c. structure, or mechanical and electrical details, see Engineers drawings		Disability Cert									
5. Proprietary items shall be fixed in strict accordance with manufacturers instructions.		Tender									
6. Sizes of proprietary items shall be checked with manufacturer.		Construction									
7. The contractor shall be responsible for the coordination of structure, finishes and services.		As Built									
		Information Only									
M:\Project Section - Current\6275 Lisieux Hall\CAD\Planning\06 General Amendments Application\Permitted Plans\Fifth Floor Plan.dwg		12/10/2023 15:41:30									

Project		6-7 HARDCOURT TERRACE, DUBLIN 2, IRELAND	
Drawing Title		RESIDENTIAL APARTMENTS, LISIEUX PARK	
Scale		1:200@A1	
Stage		Planning	
Project Code		6275	
Job		LIS - BKD	
Zone		00	
Level		05	
Type		DR - A-	
Sheet no.		500	
Status		P01	
Rev			

bkdarchitects		BURKE-KENNEDY DOYLE	
www.bkd.ie			