



BLOCK 3

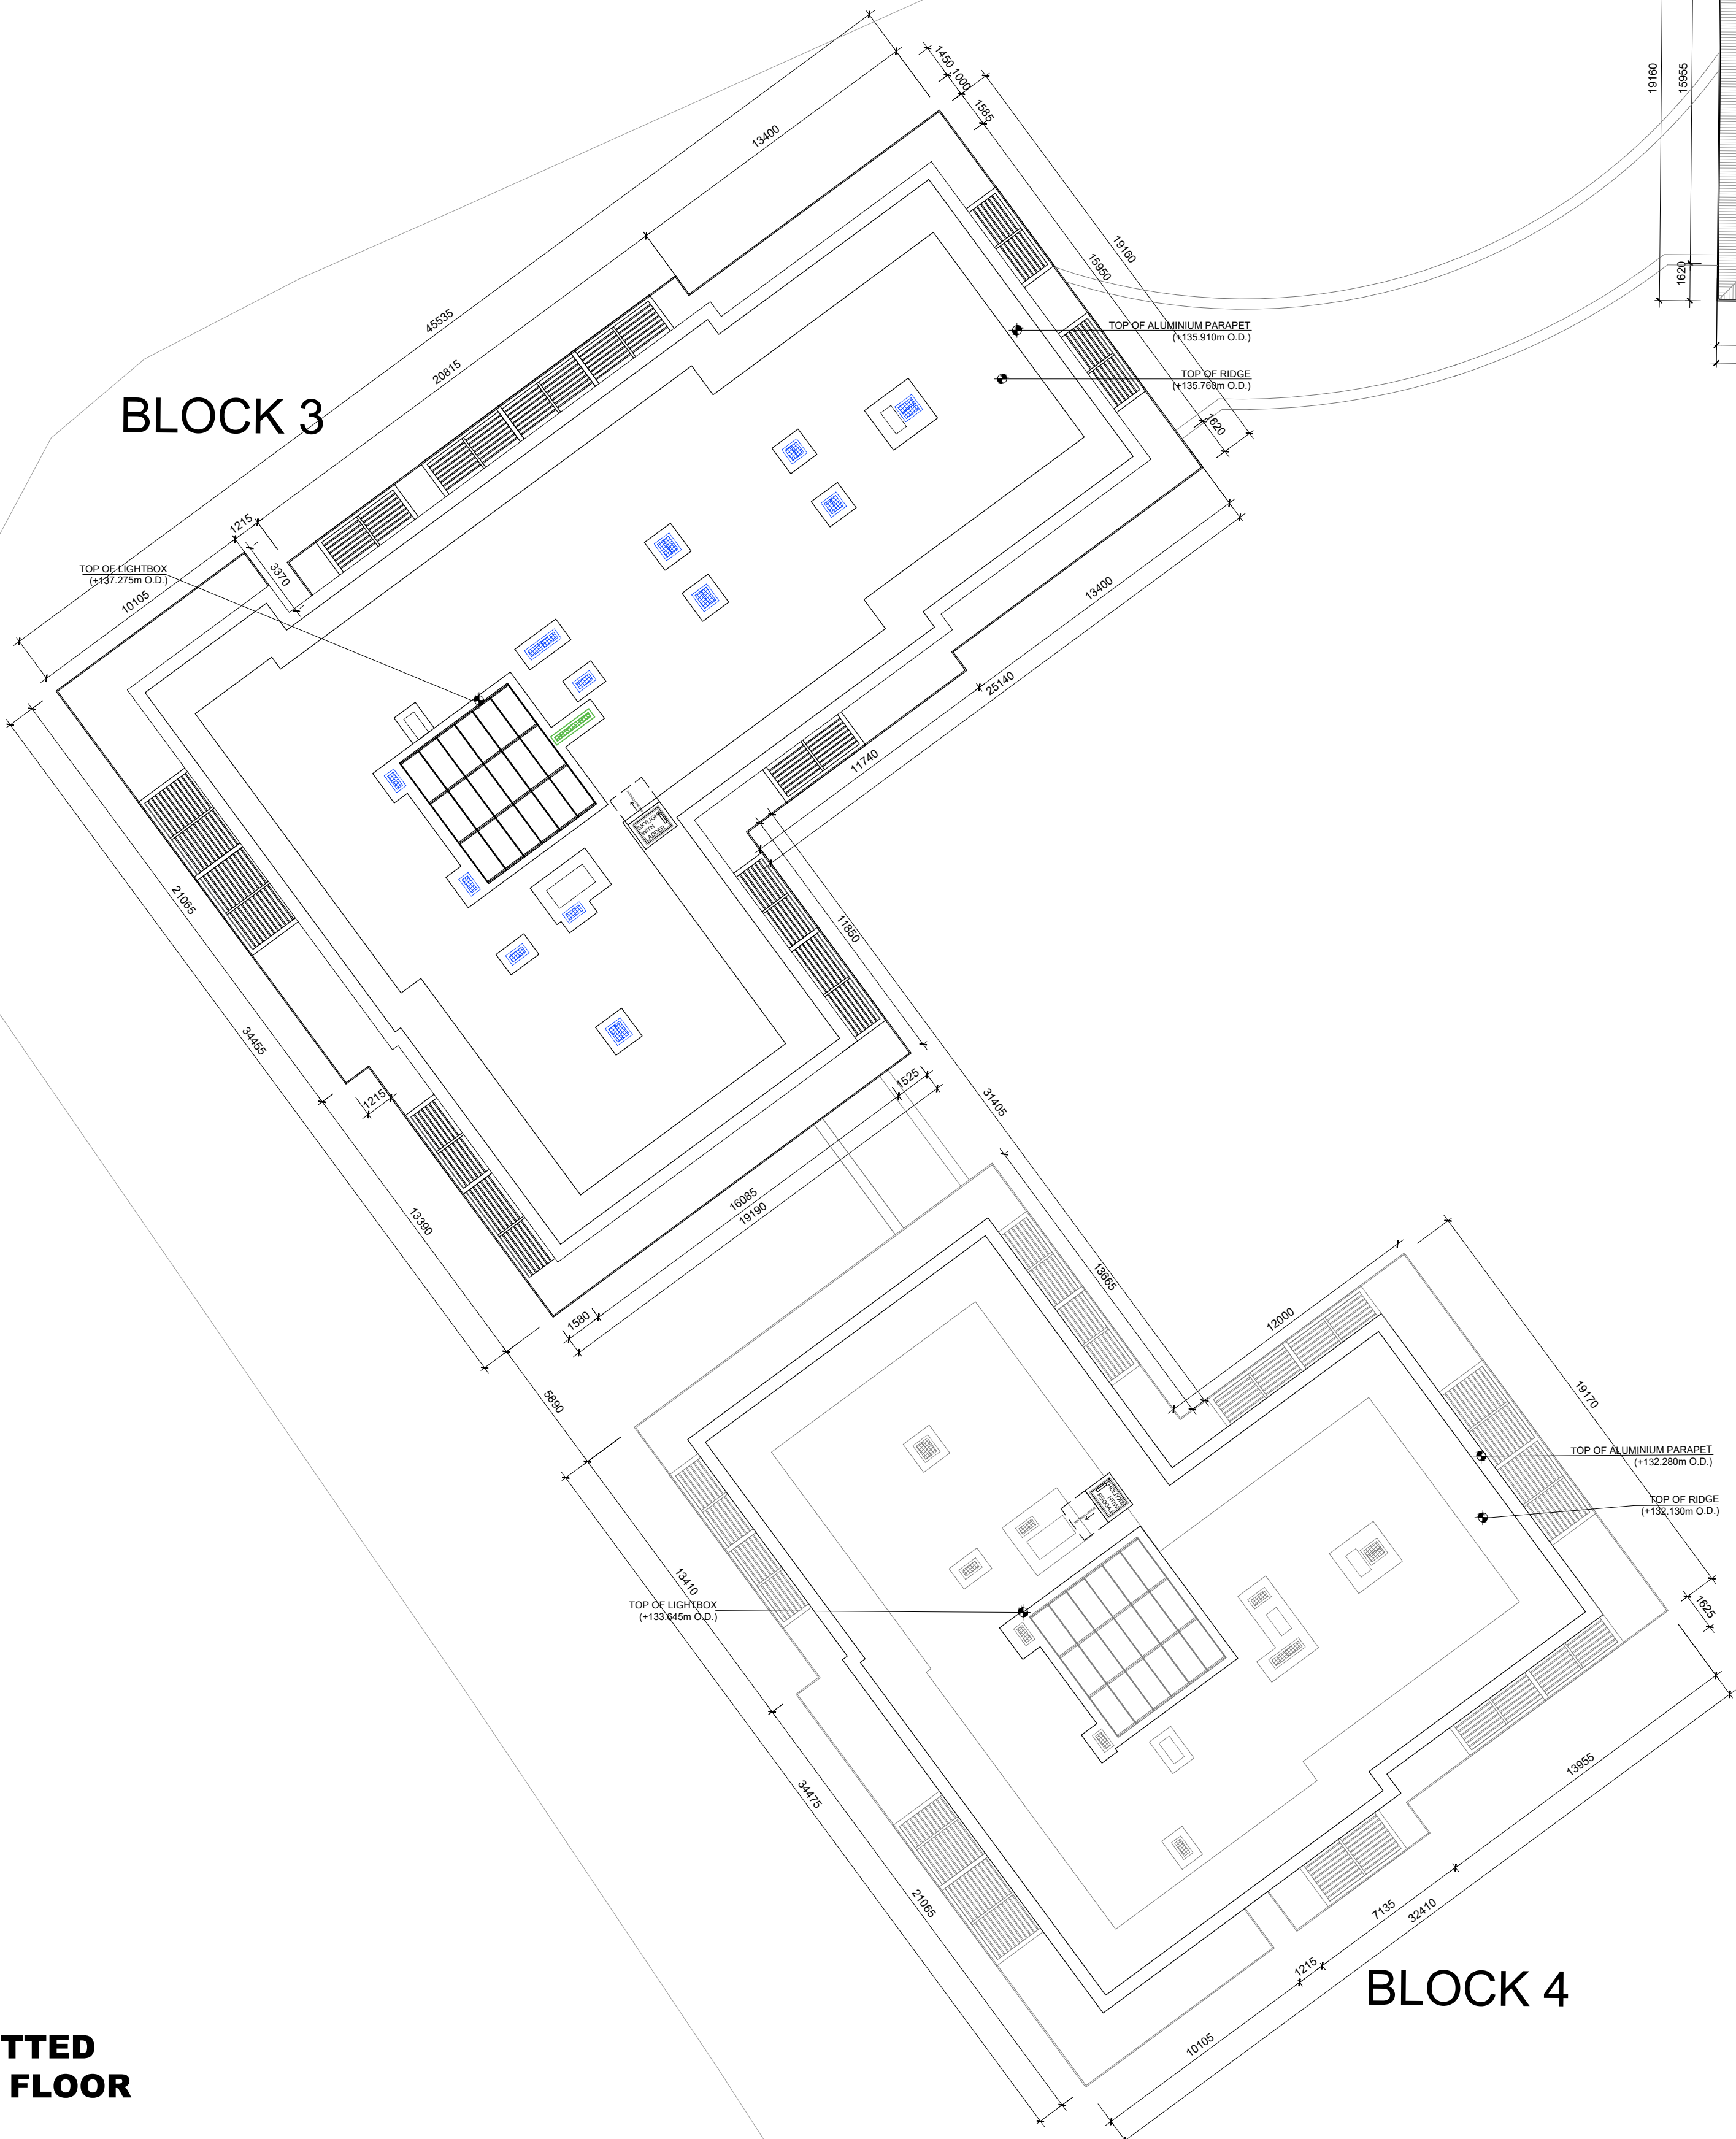


BLOCK 4

BLOCK 1

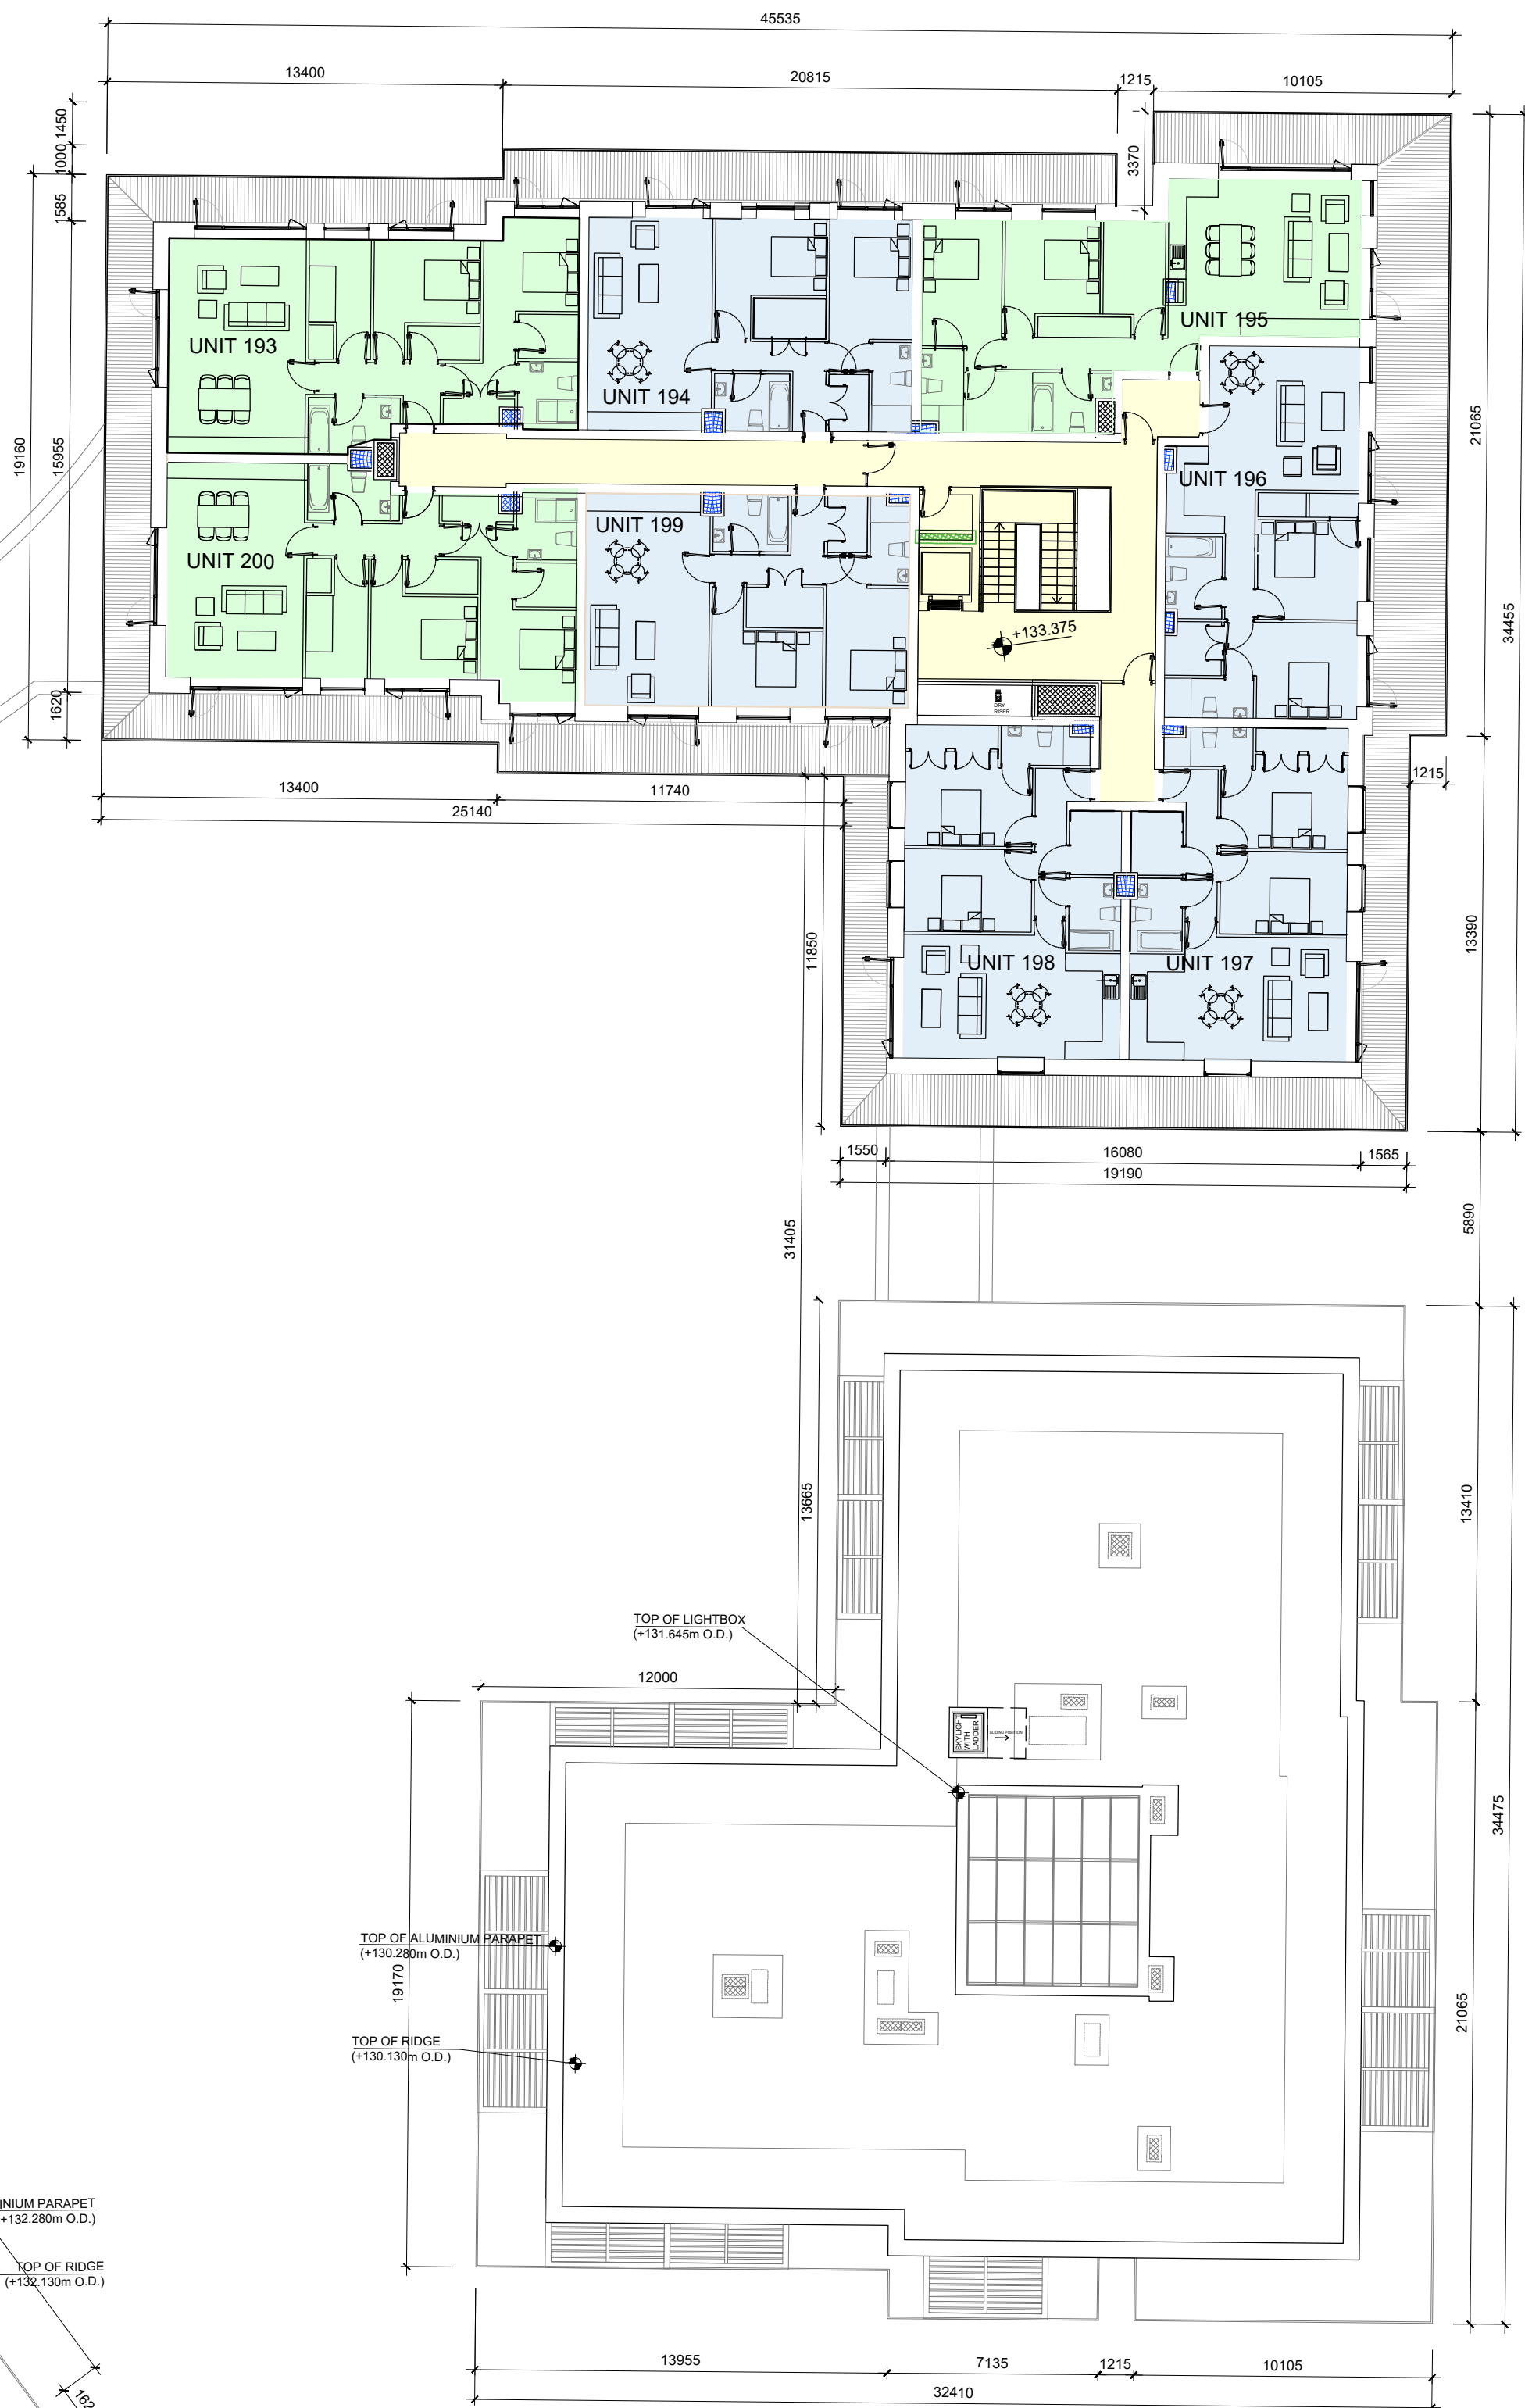


BLOCK 2

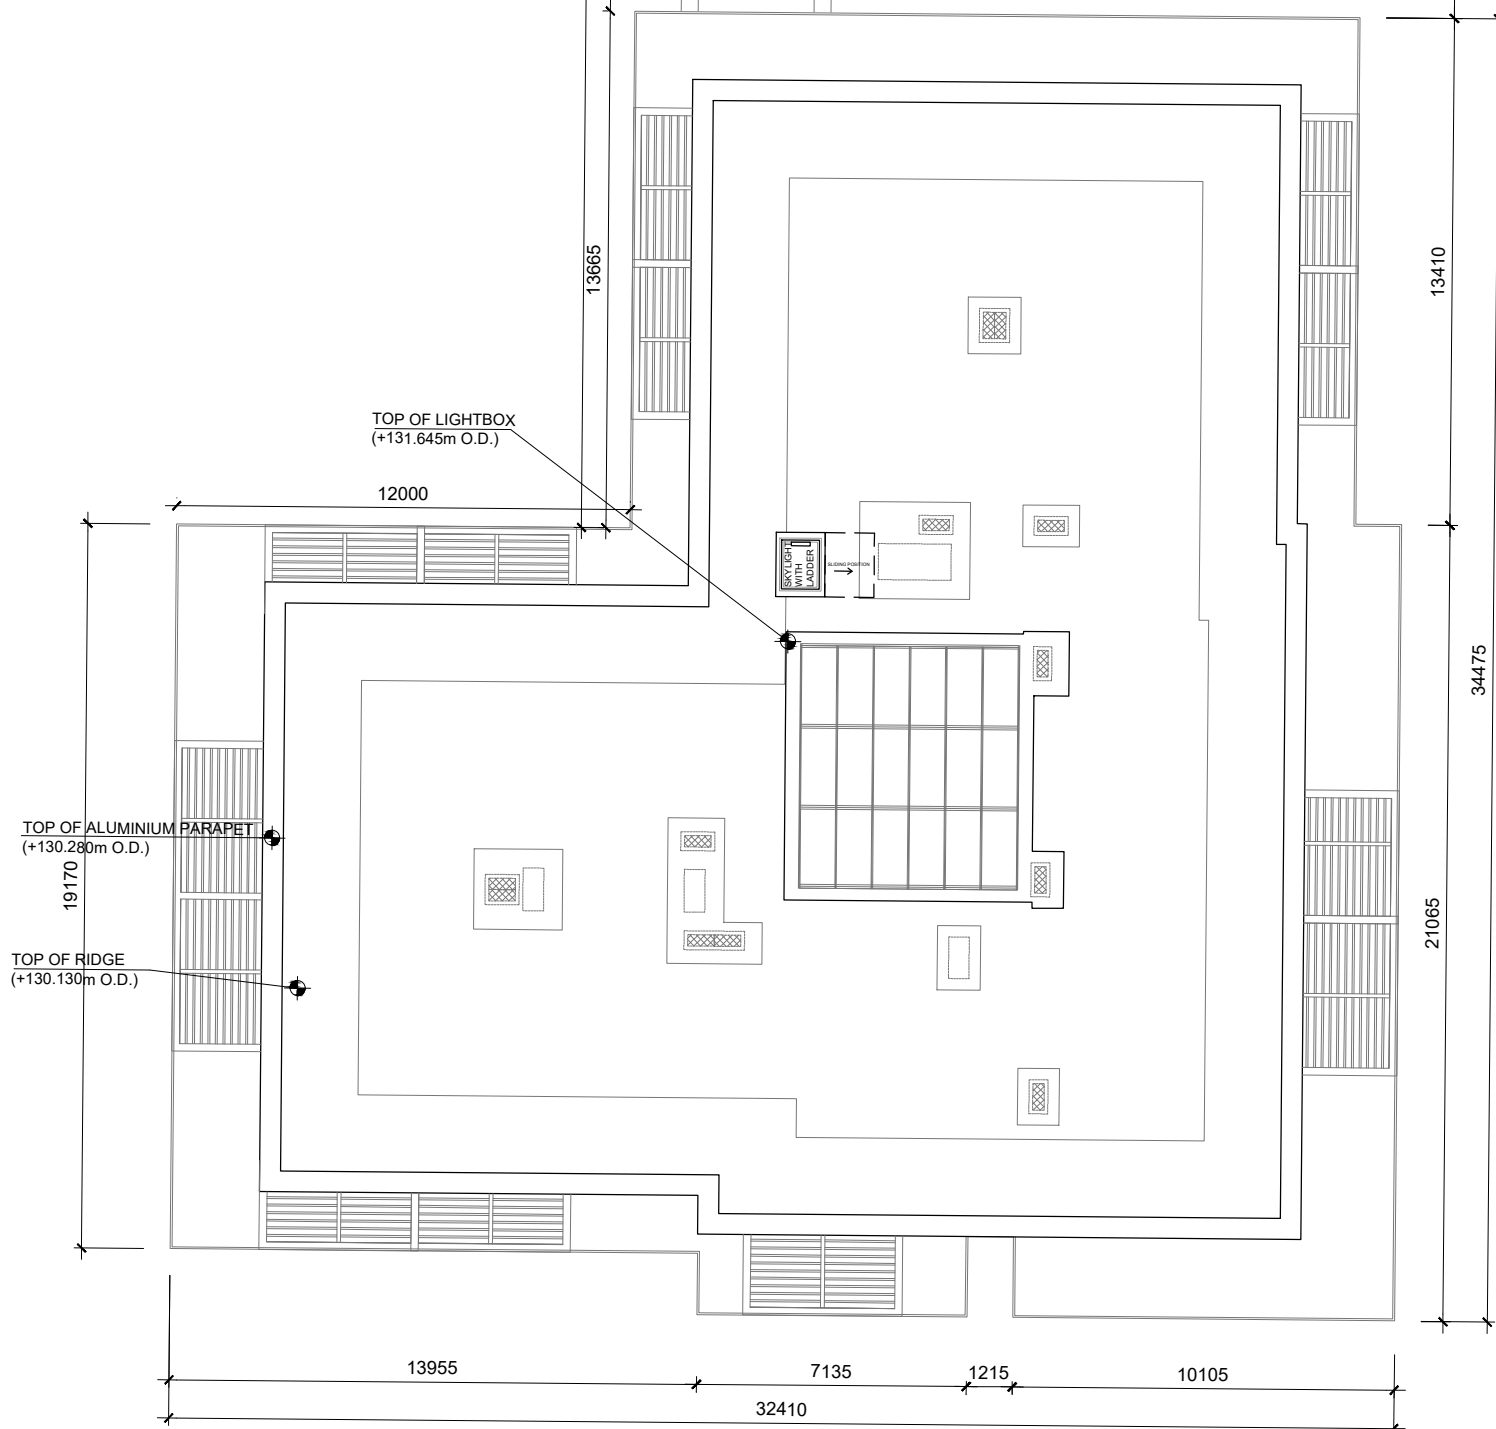

LEGEND:

- 1 BED STUDIO
- 1 BED APARTMENT
- 2 BED APARTMENT
- 3 BED APARTMENT

LISIEUX PARK

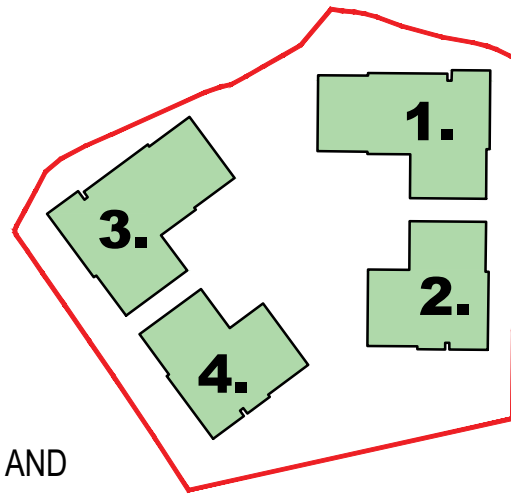

PERMITTED SIXTH FLOOR

Notes 1. Copyright Reserved 2. Work to figured dimensions only. Do not scale drawing. 3. The contractor is responsible for checking all levels and dimensions on site and shall refer all discrepancies to the Architect 4. Where appropriate, for details of r.c. structure, or mechanical and electrical details, see Engineers drawings 5. Proprietary items shall be fixed in strict accordance with manufacturers instructions. 6. Sizes of proprietary items shall be checked with manufacturer. 7. The contractor shall be responsible for the coordination of structure, finishes and services.	Issue Status					No.	Date	Revision	Initials
	Progress					P01	06.10.2023	Planning Permission Application - General Amendments	MG
	Planning Application								
	Fire Cert								
	Disability Cert								
	Tender								
	Construction								
	As Built								
	Information Only								

PERMITTED DRAWING FROM PLANNING APPLICATION AND
COMPLIANCE SUBMISSION REF. ABP-307415-20

Project										RESIDENTIAL APARTMENTS, LISIEUX PARK Murphystown Road, leopards town, Dublin 18										6-7 HARDCOURT TERRACE, DUBLIN 2, IRELAND t: 303-1-818 2100 f: 303-1-878 7385 e: architects@bkd.ie www.bkd.ie											
Drawing Title										Permitted Sixth Floor Plan										<div>bkdarchitects</div> <div>BURKE-KENNEDY DOYLE</div>											
Stage		Scale		Drawn		MG		Apd		FF		Date		03.04.2023																	
Planning		1:200@A1																													
Project Code		job		origin		zone		level		type		dis		sheet no.		status		rev													
6275		LIS		BKD		-		00		-		06		-		DR		-		A- 500 P01											